



Type



Plans

PLP98-0050

Permit Number

367

Street Number

W ROBLES AVE

Street Name

BEL


Community Code

134-074-022

APN

PARKING TABULATION

WEST PARCEL	
BUS (12x42)	63 STALLS
BUS (12x21)	12 STALLS
EAST PARCEL	
BUS (12x42)	31 STALLS
BUS (12x21)	1 STALL
AUTO (STANDARD)	42 STALLS
AUTO (COMPACT)	16 STALLS
TOTAL	
BUS (12x42)	94 STALLS
BUS (12x21)	13 STALLS
AUTO	58 STALLS
TOTAL	166 STALLS

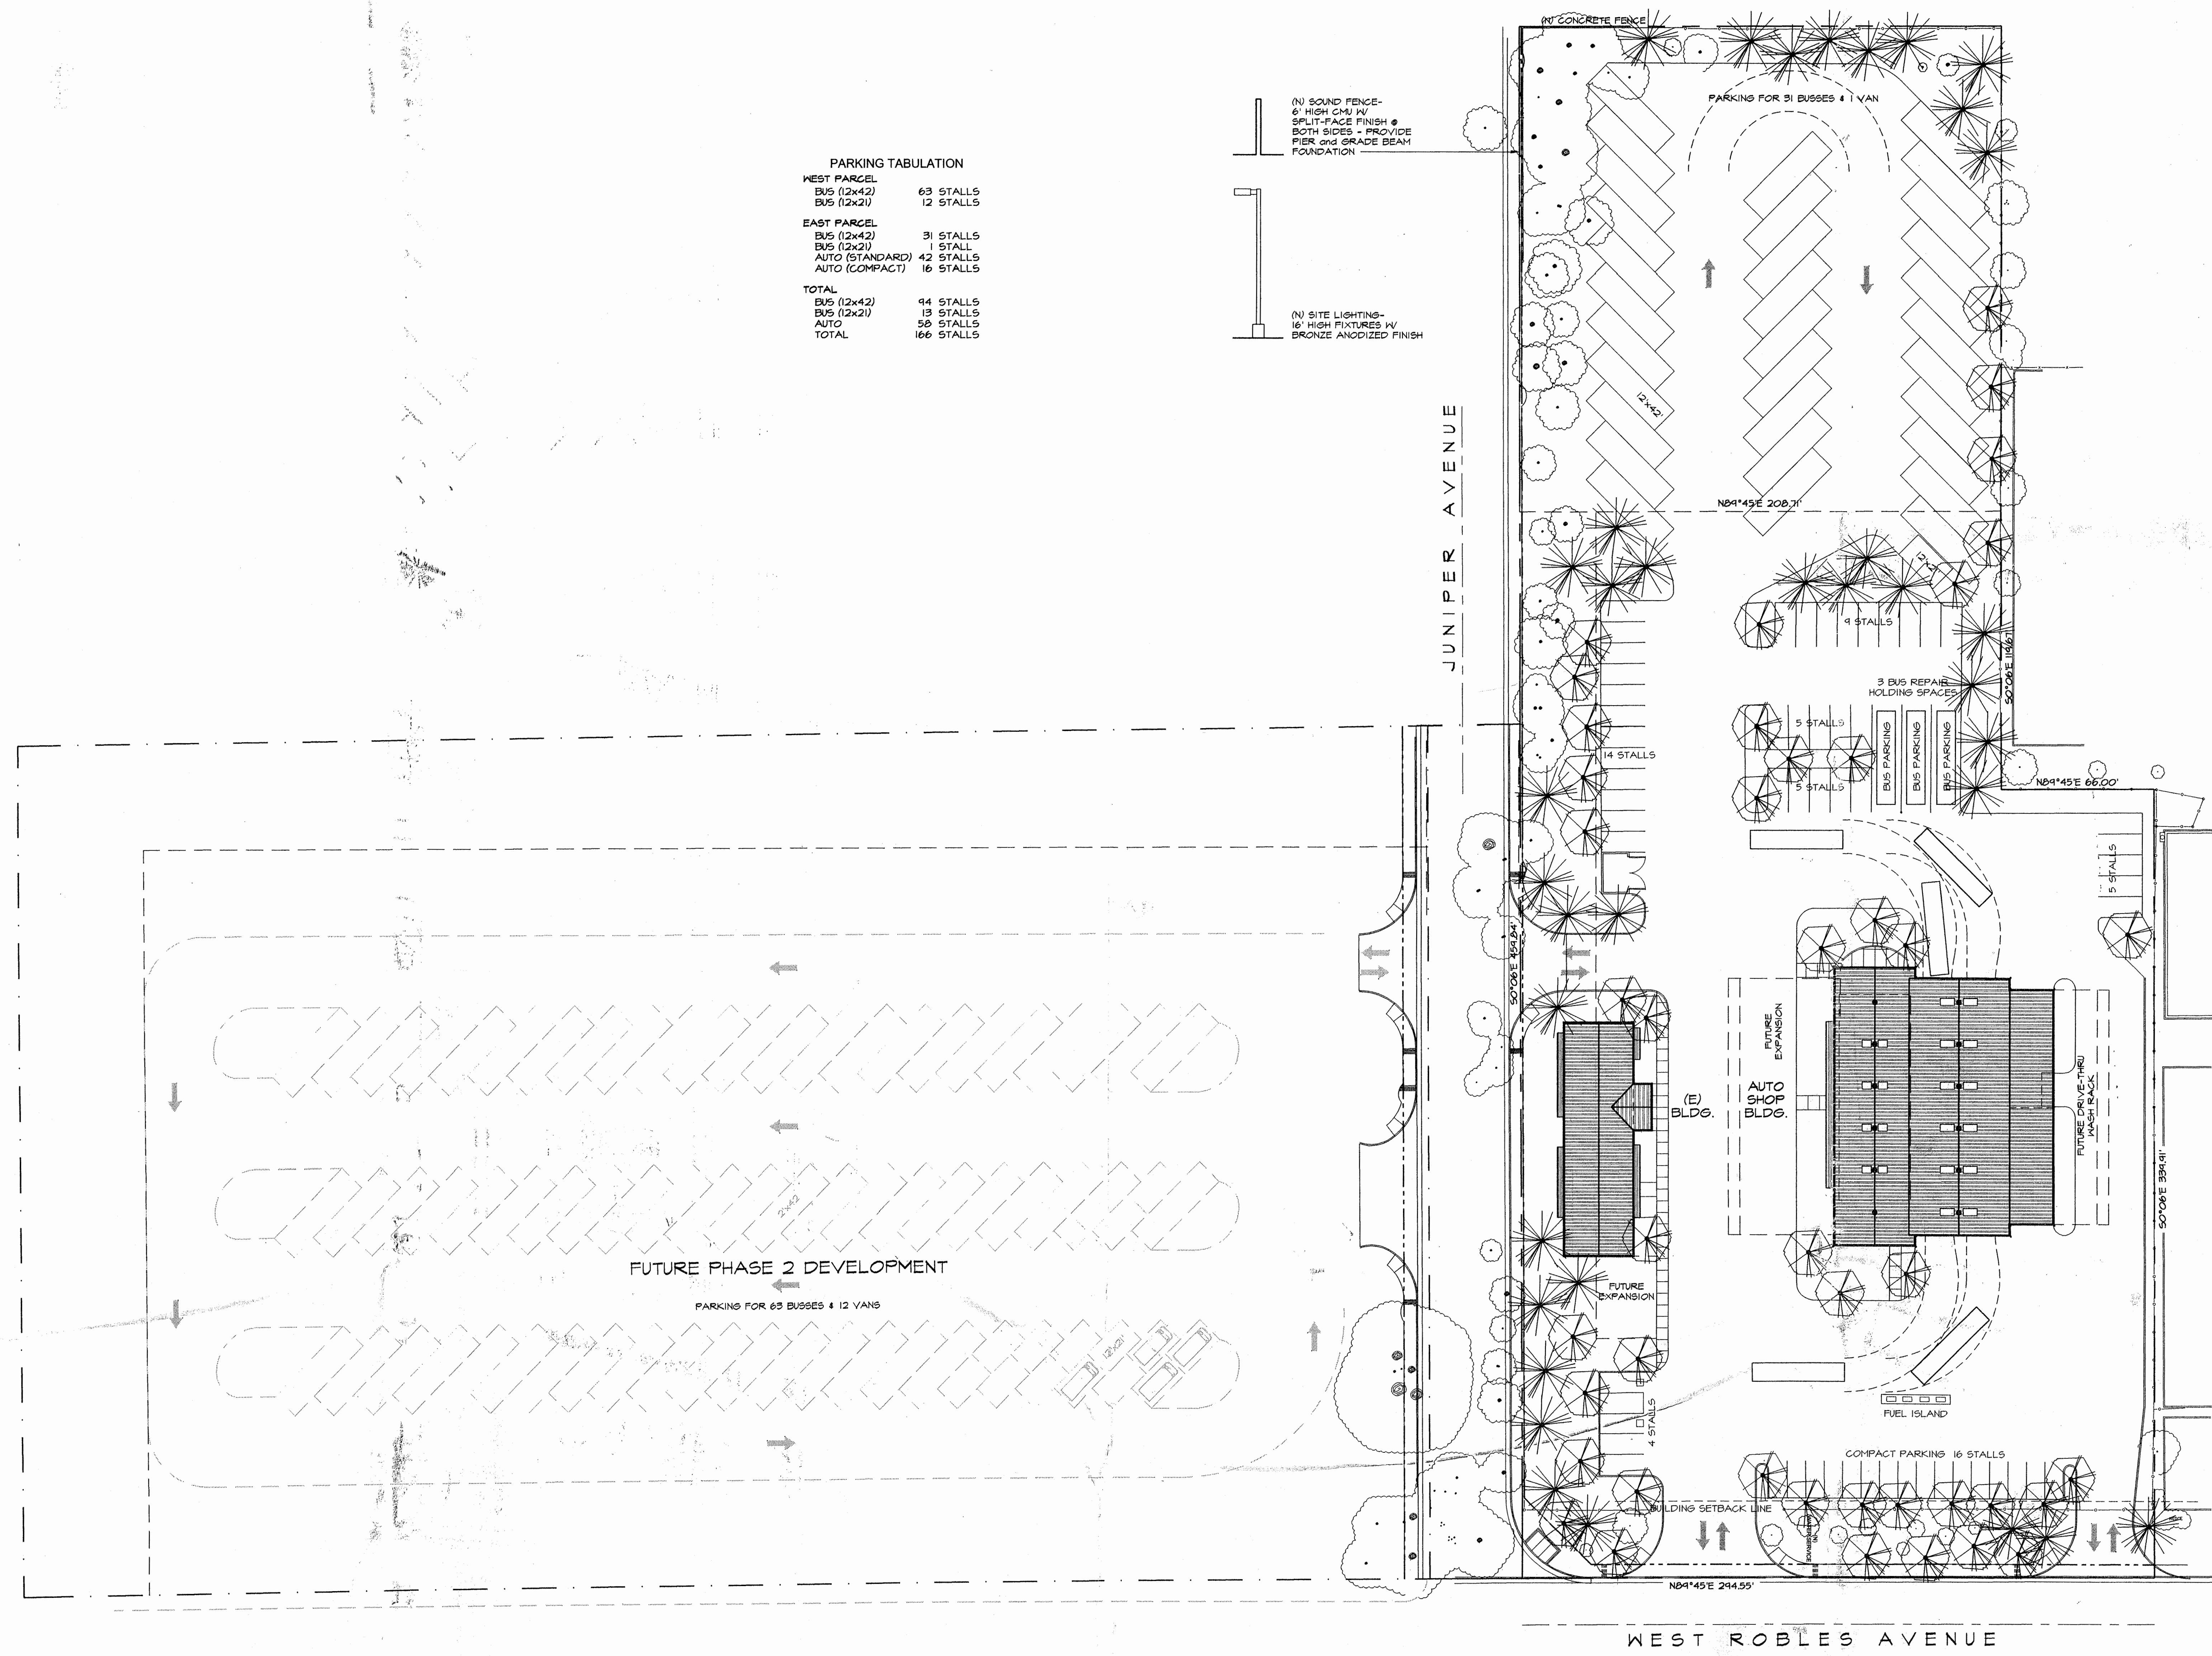

(N) SOUND FENCE-
6' HIGH CHU IV
SPLIT-FACE FINISH @
BOTH SIDES - PROVIDE
PIER AND GRADE BEAM
FOUNDATION

(N) SITE LIGHTING-
16' HIGH FIXTURES IV
BRONZE ANODIZED FINISH

DESIGNED BY: [Signature]
CHECKED BY: [Signature]
APPROVED BY: [Signature]
NEEDS MODIFICATIONS AS INDICATED

BY: [Signature]


SCALE: 1" = 30'

NORTH




PHASE 1 SITE PLAN


WEST COUNTY TRANSPORTATION
JULY 19, 2000

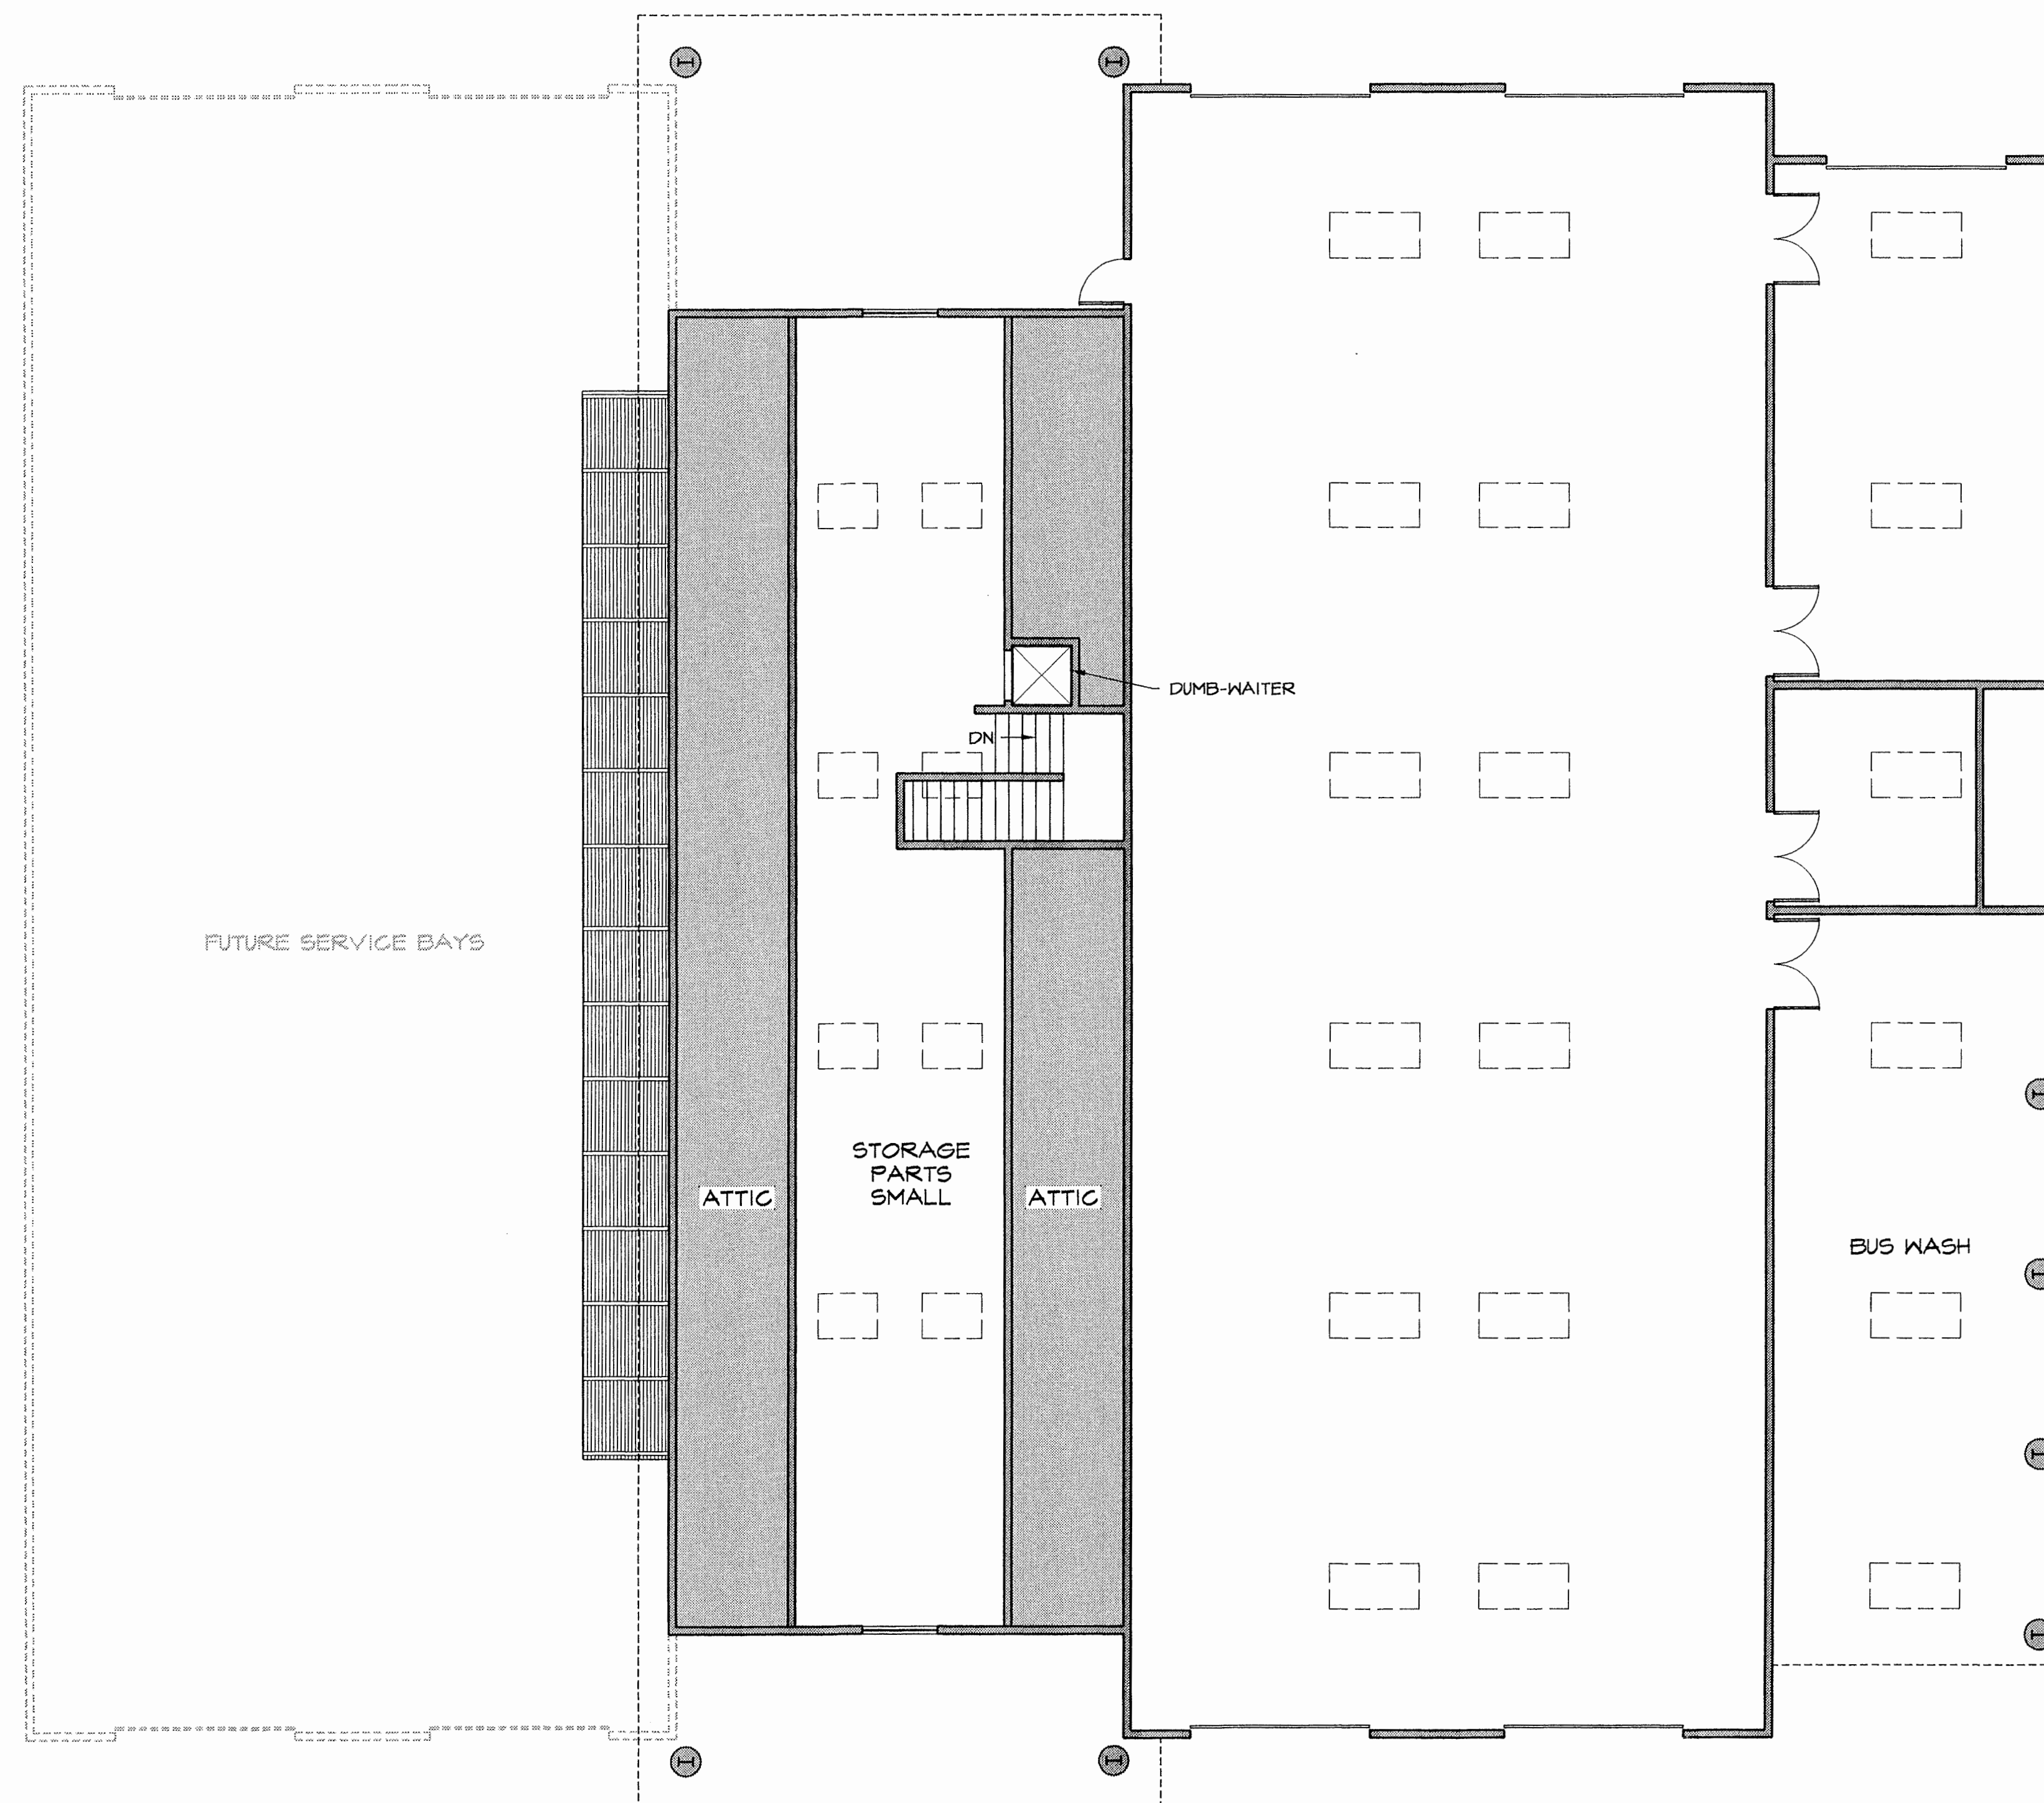

UPPER LEVEL FLOOR PLAN

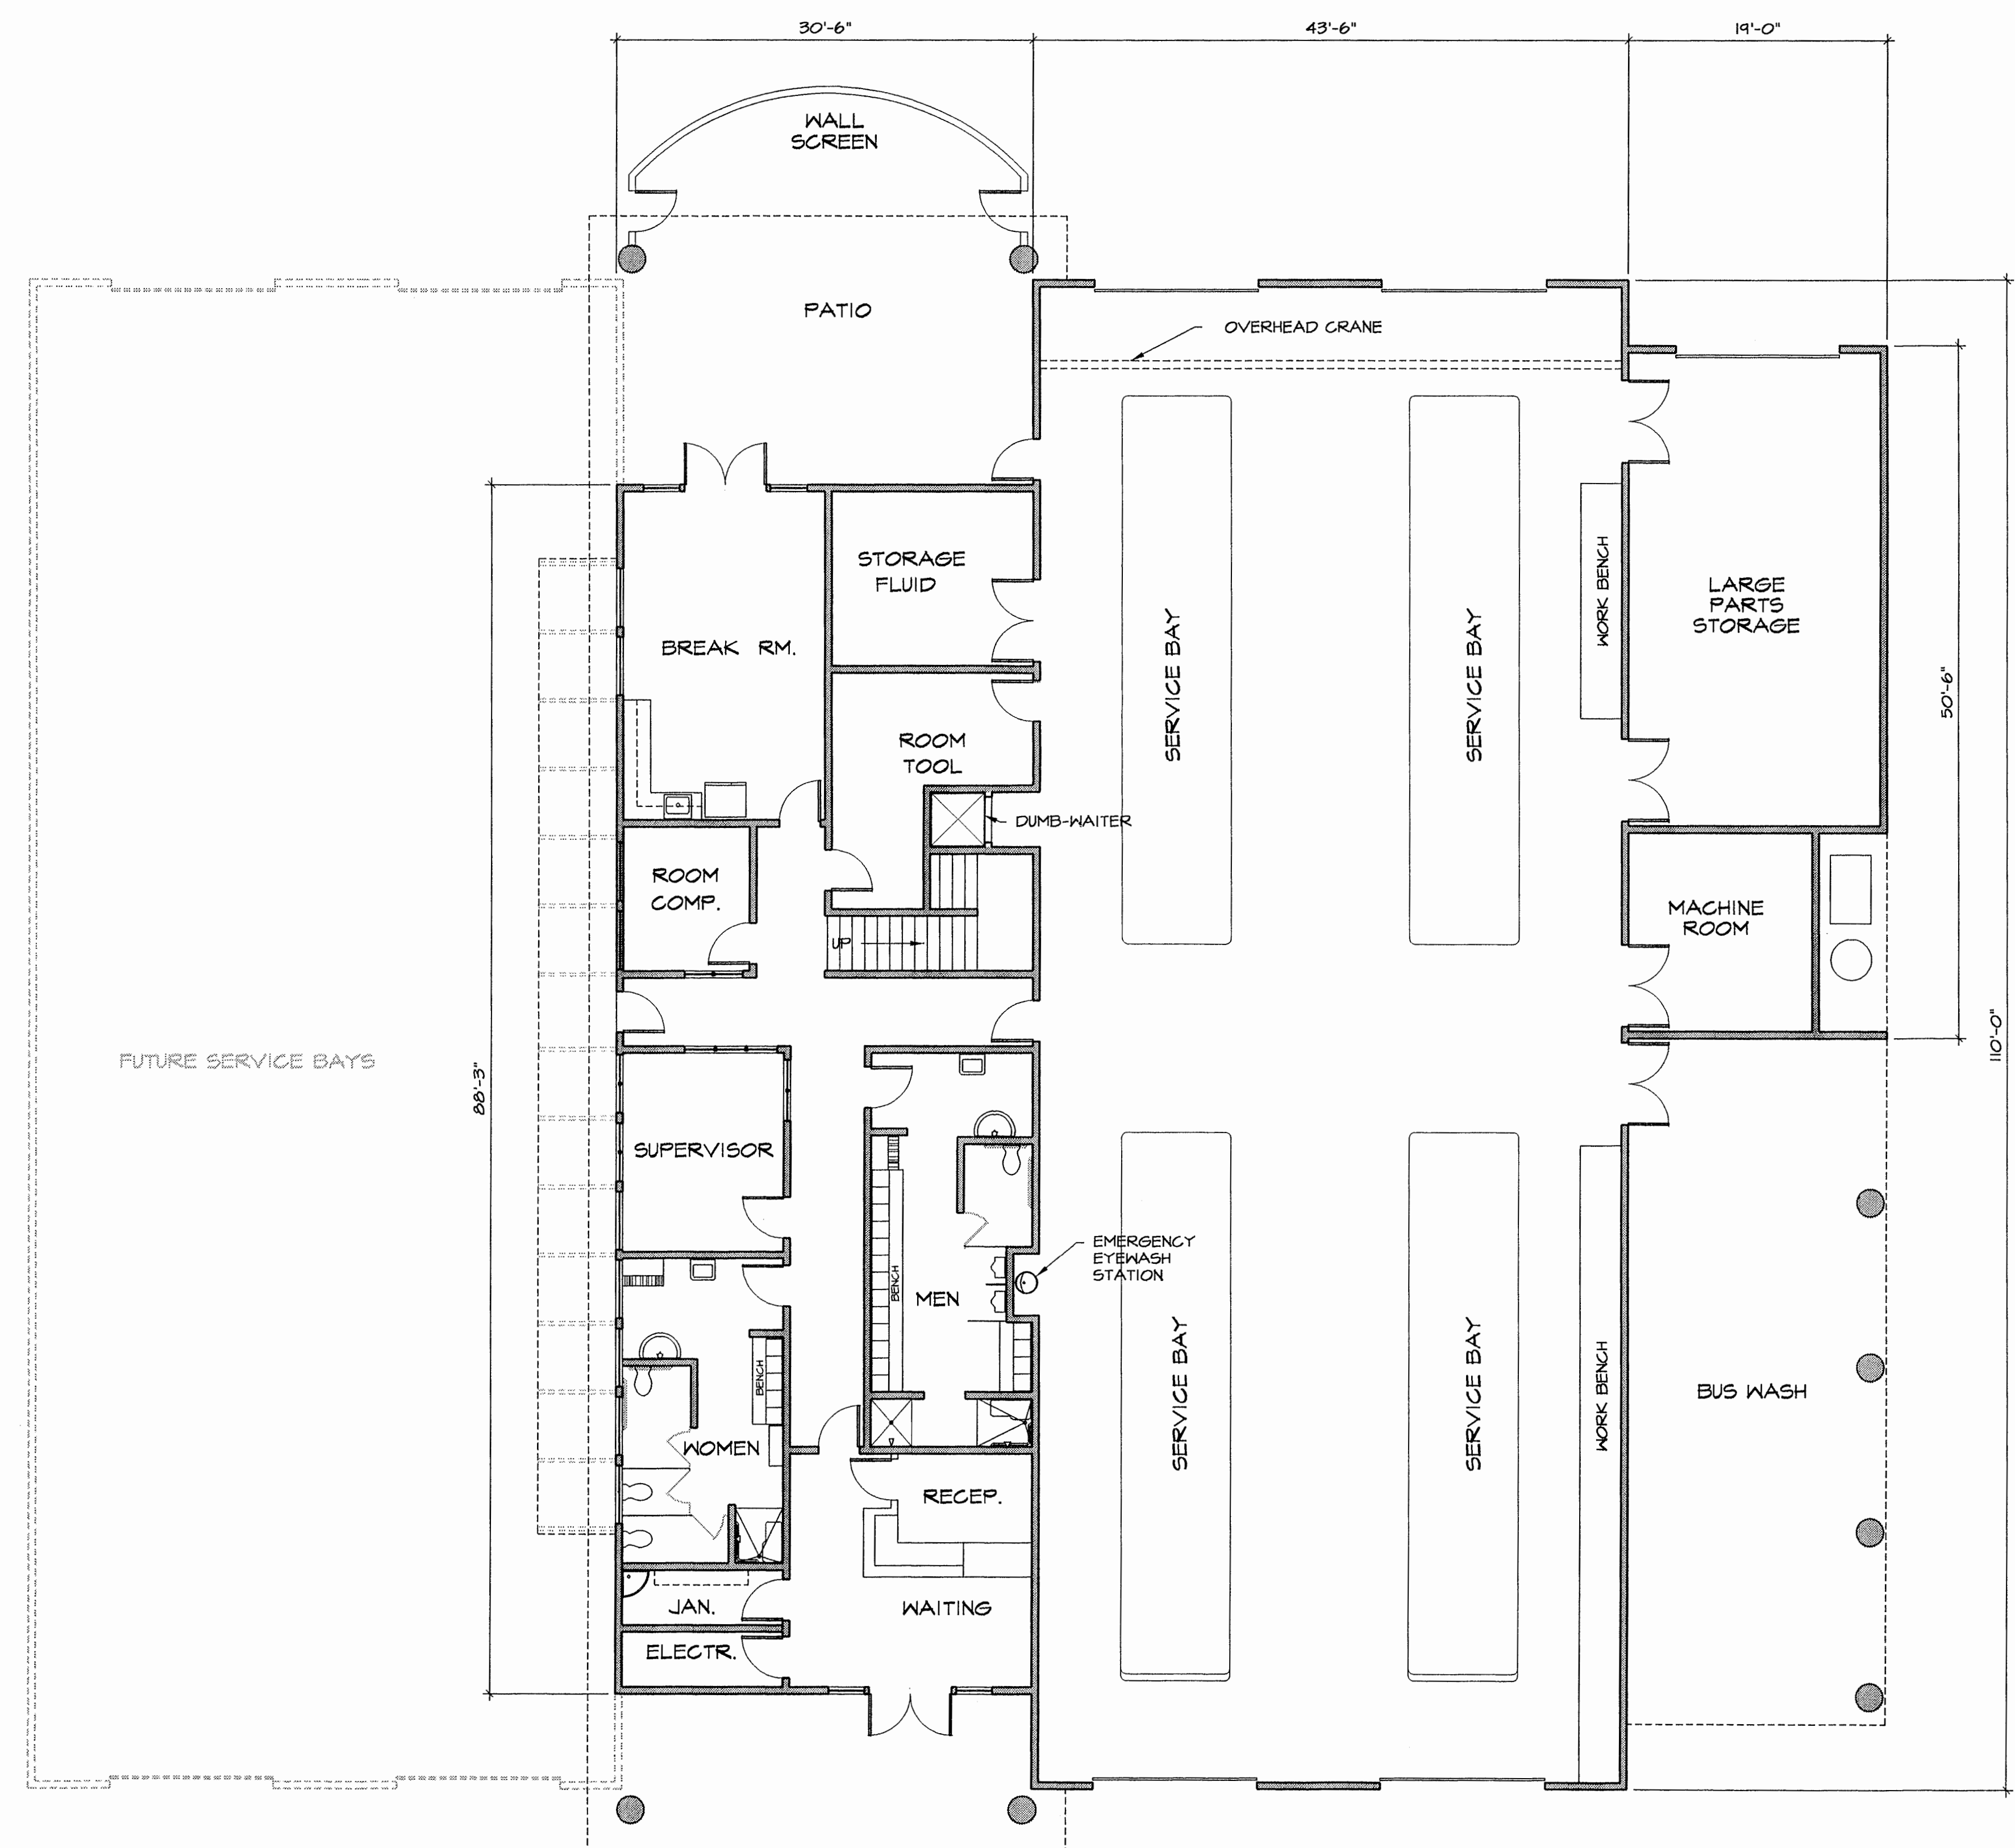


LOWER LEVEL FLOOR PLAN

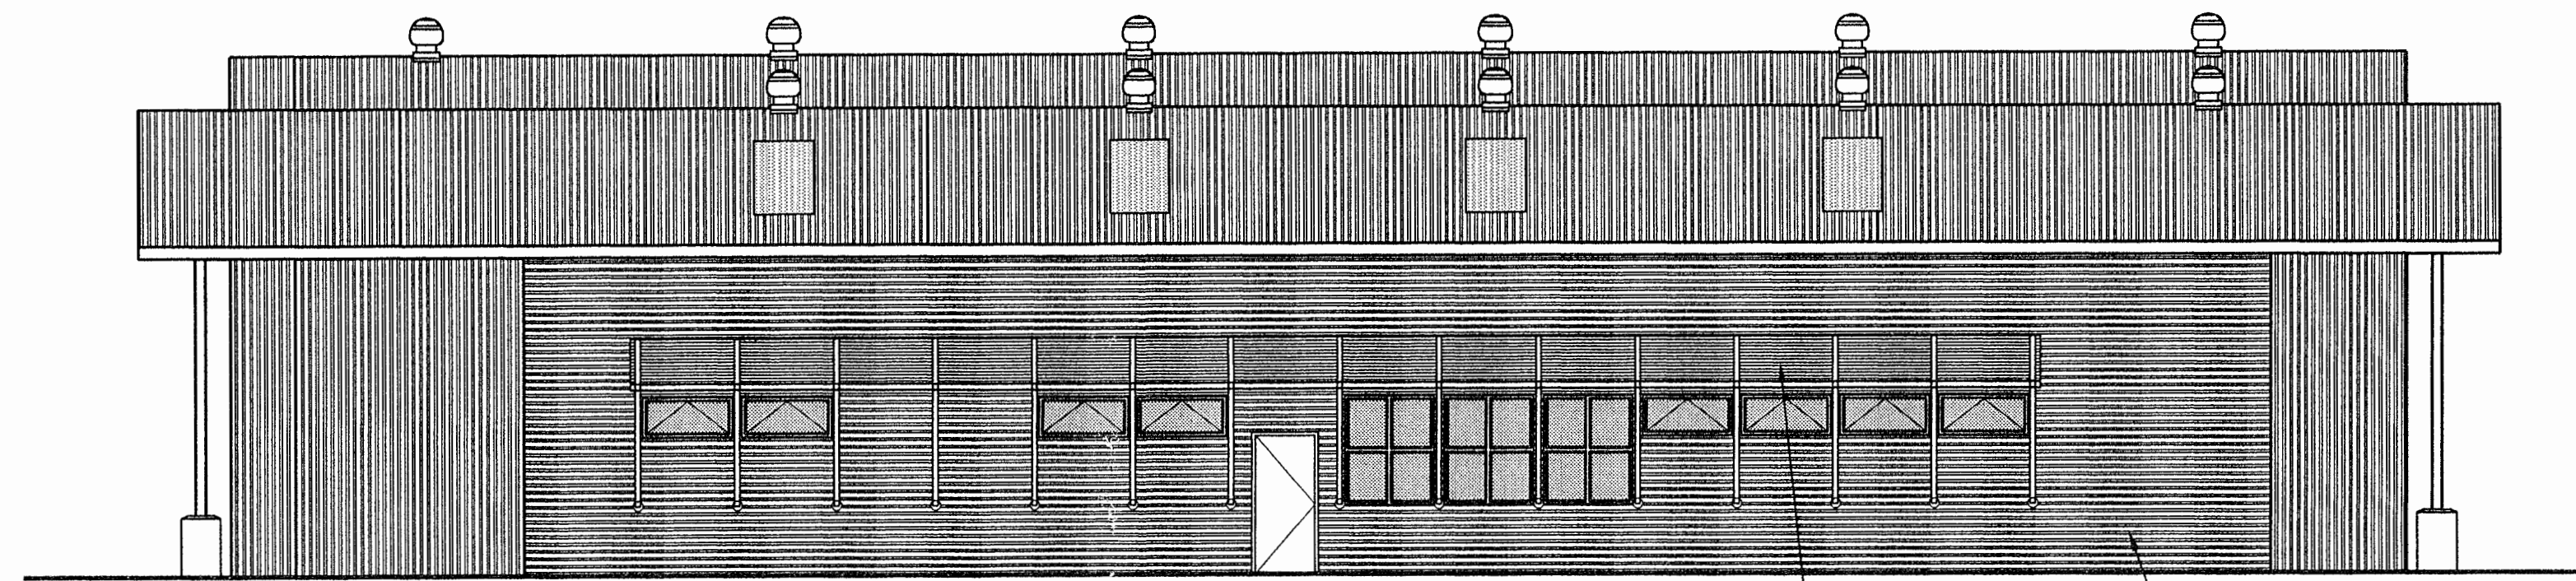


WEST ELEVATION

METAL AWNINGS
OVER WINDOWS

HORIZONTAL
METAL SIDING

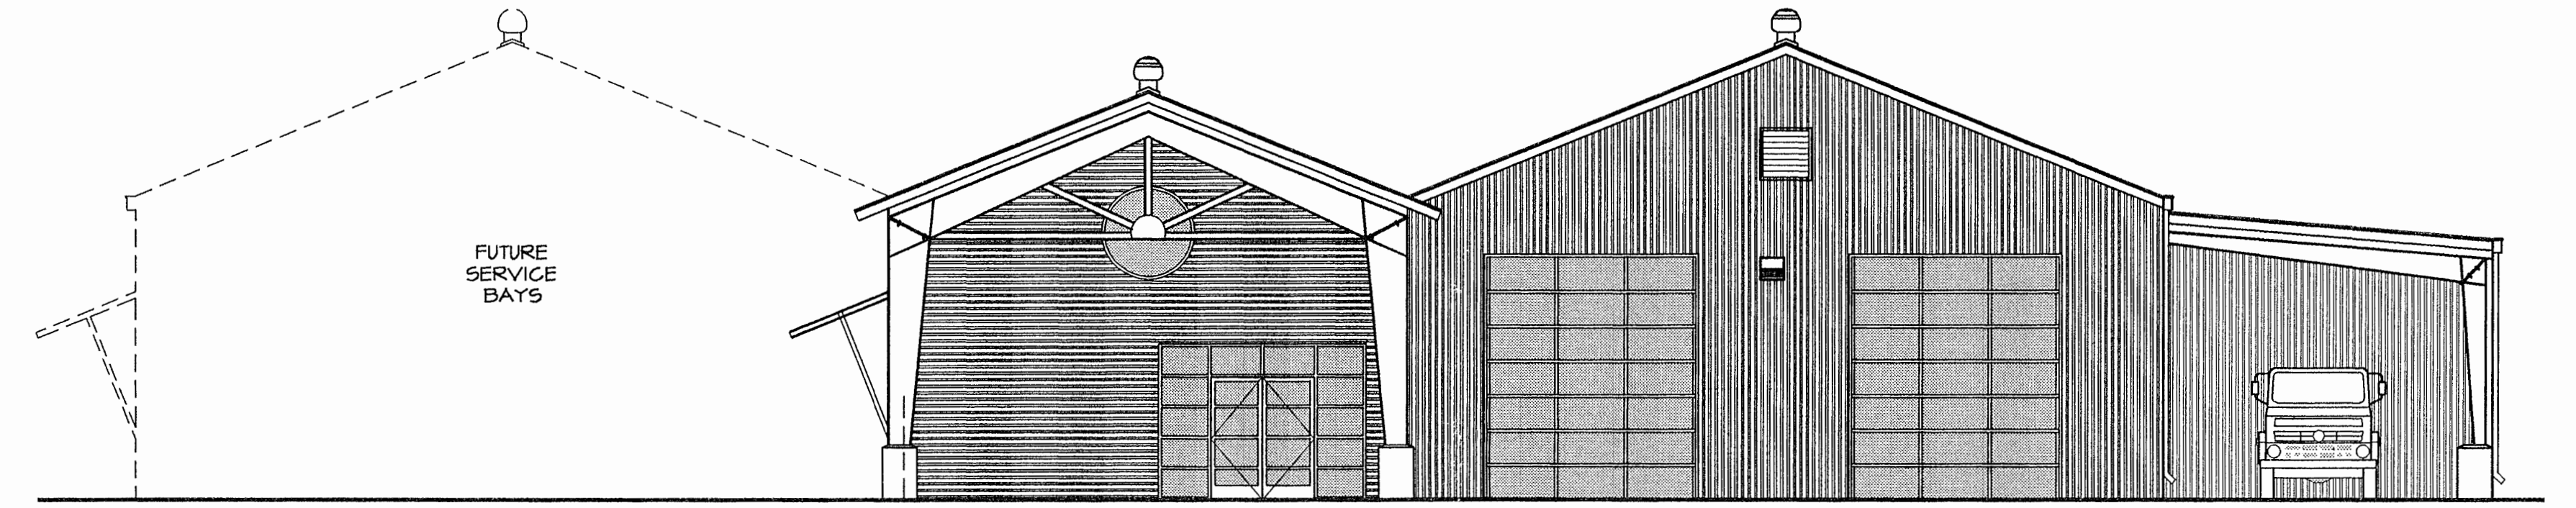

SOUTH ELEVATION

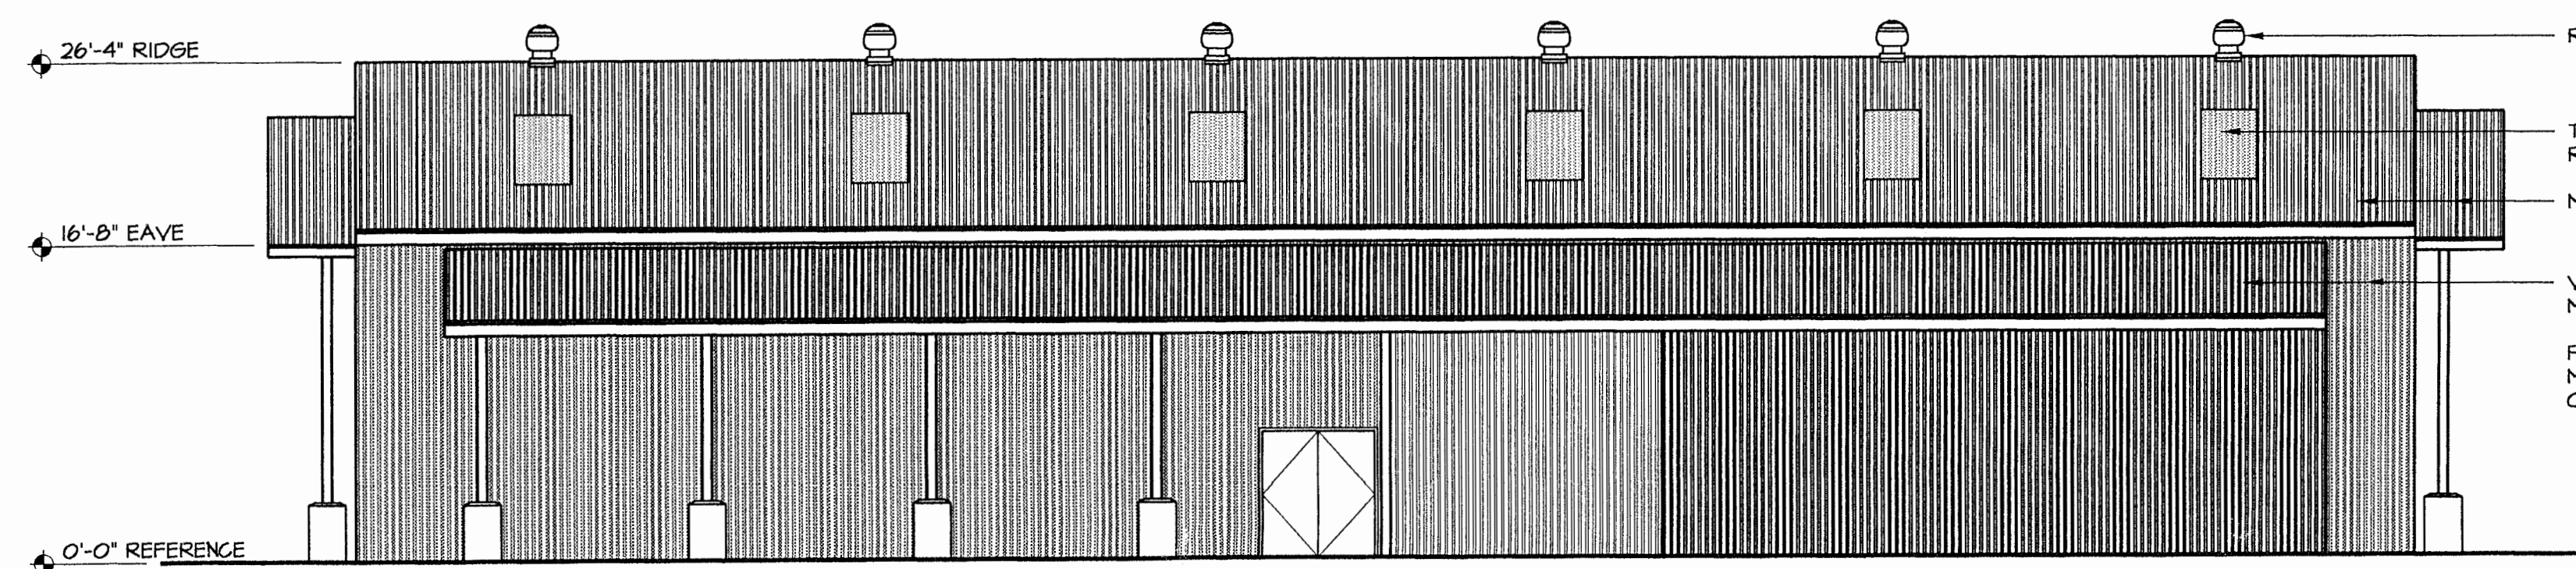

EAST ELEVATION


ROOF VENTILATORS

TRANSPARENT
ROOF PANELS

METAL ROOFING

VERTICAL
METAL SIDING


PAINTED
METAL FRAMES ON
CONCRETE PEDESTALS

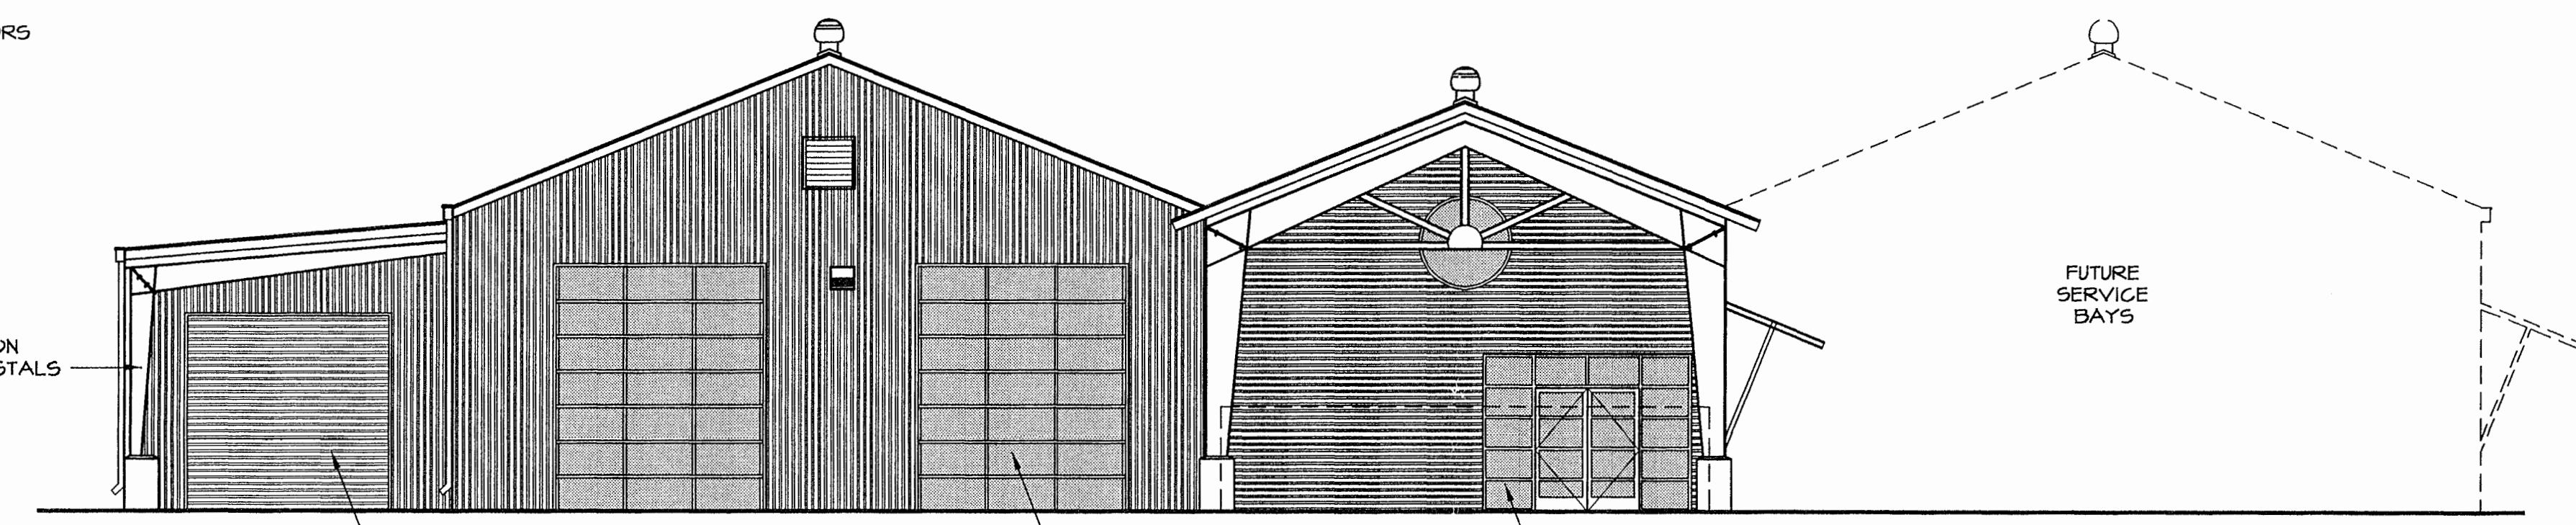

NORTH ELEVATION




ELEVATIONS

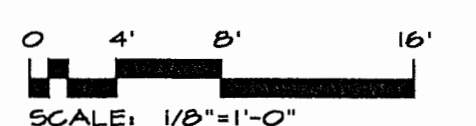


WEST COUNTY TRANSPORTATION

APRIL 19, 2000

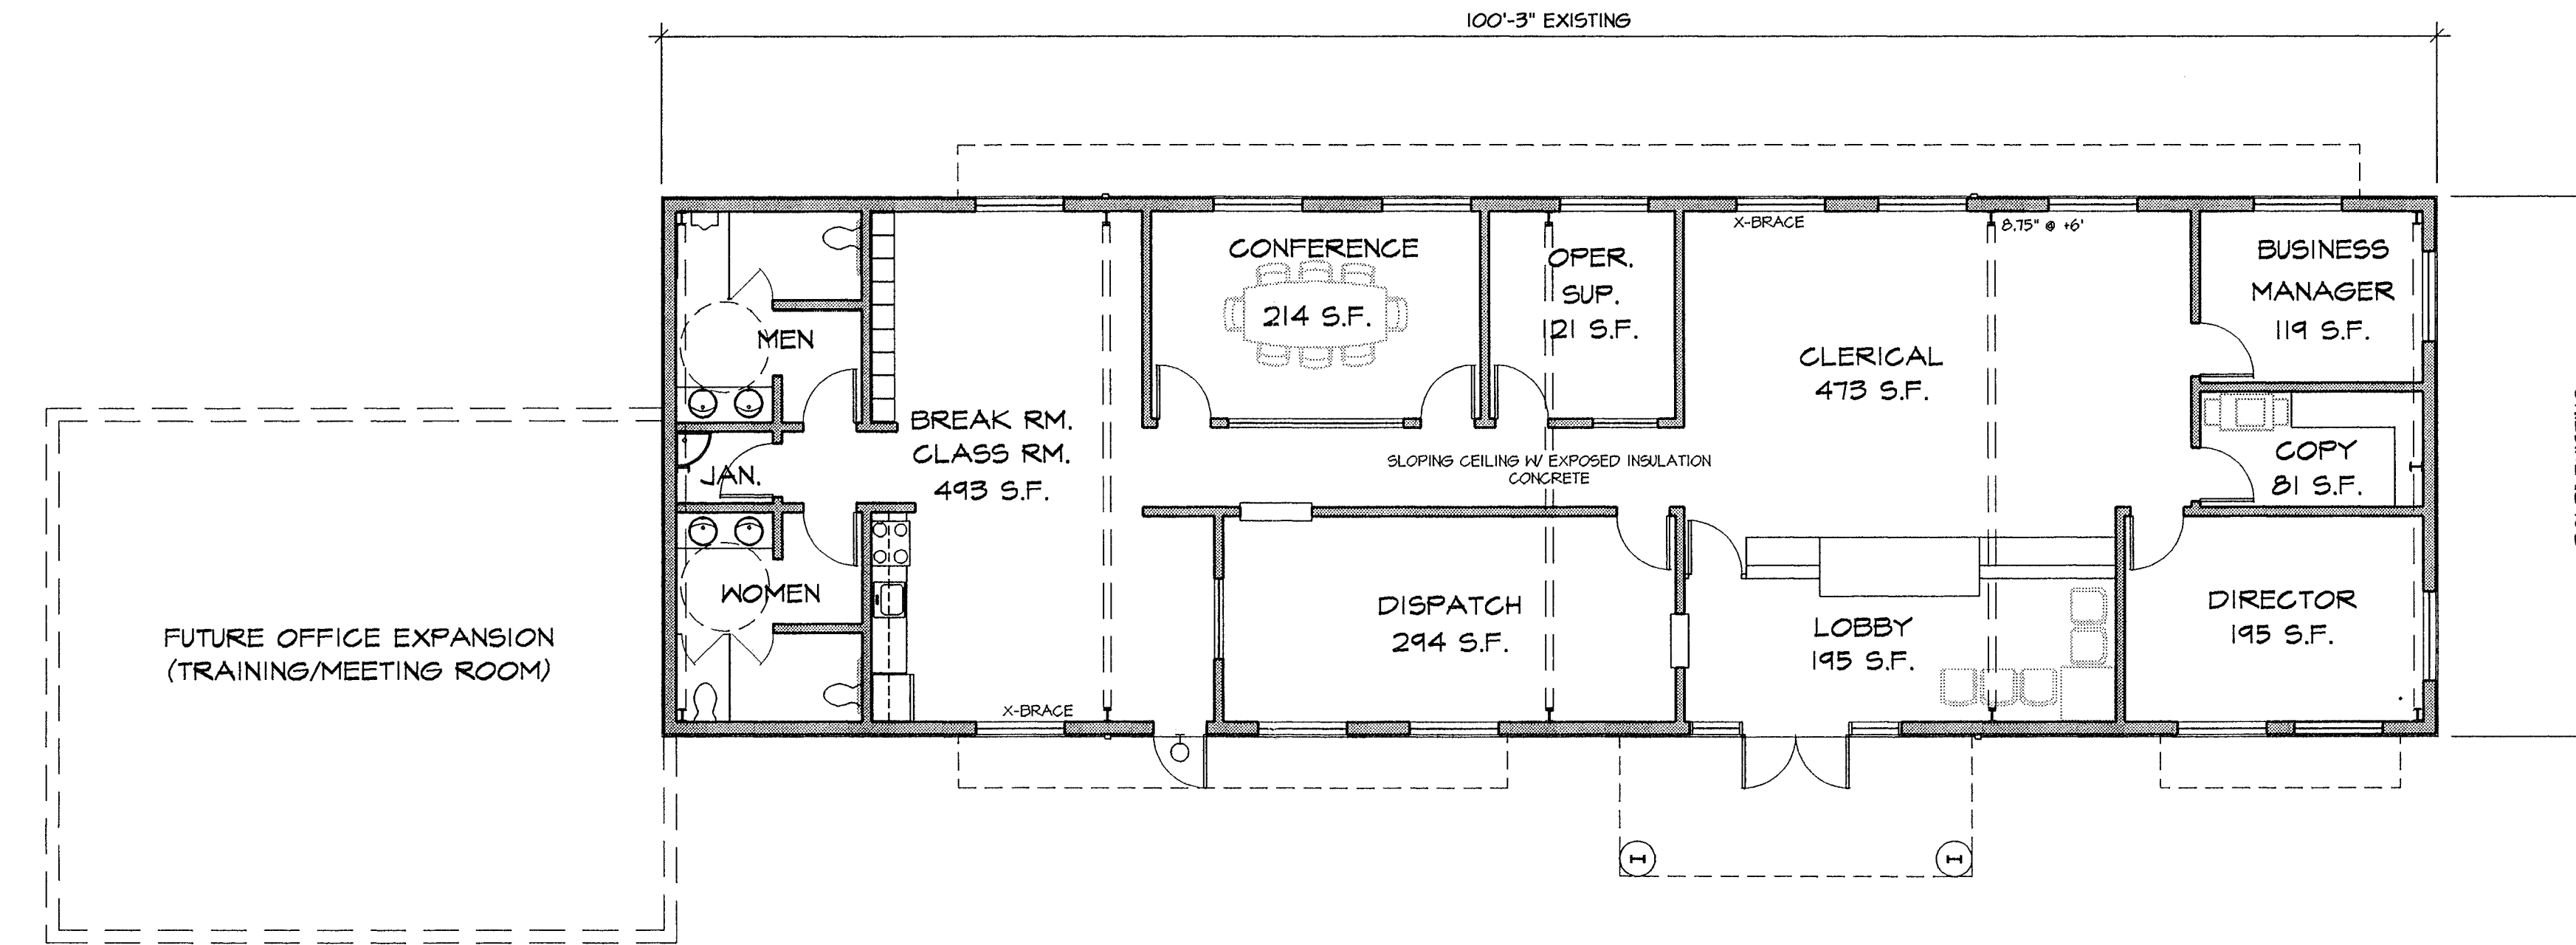


FLOOR PLAN

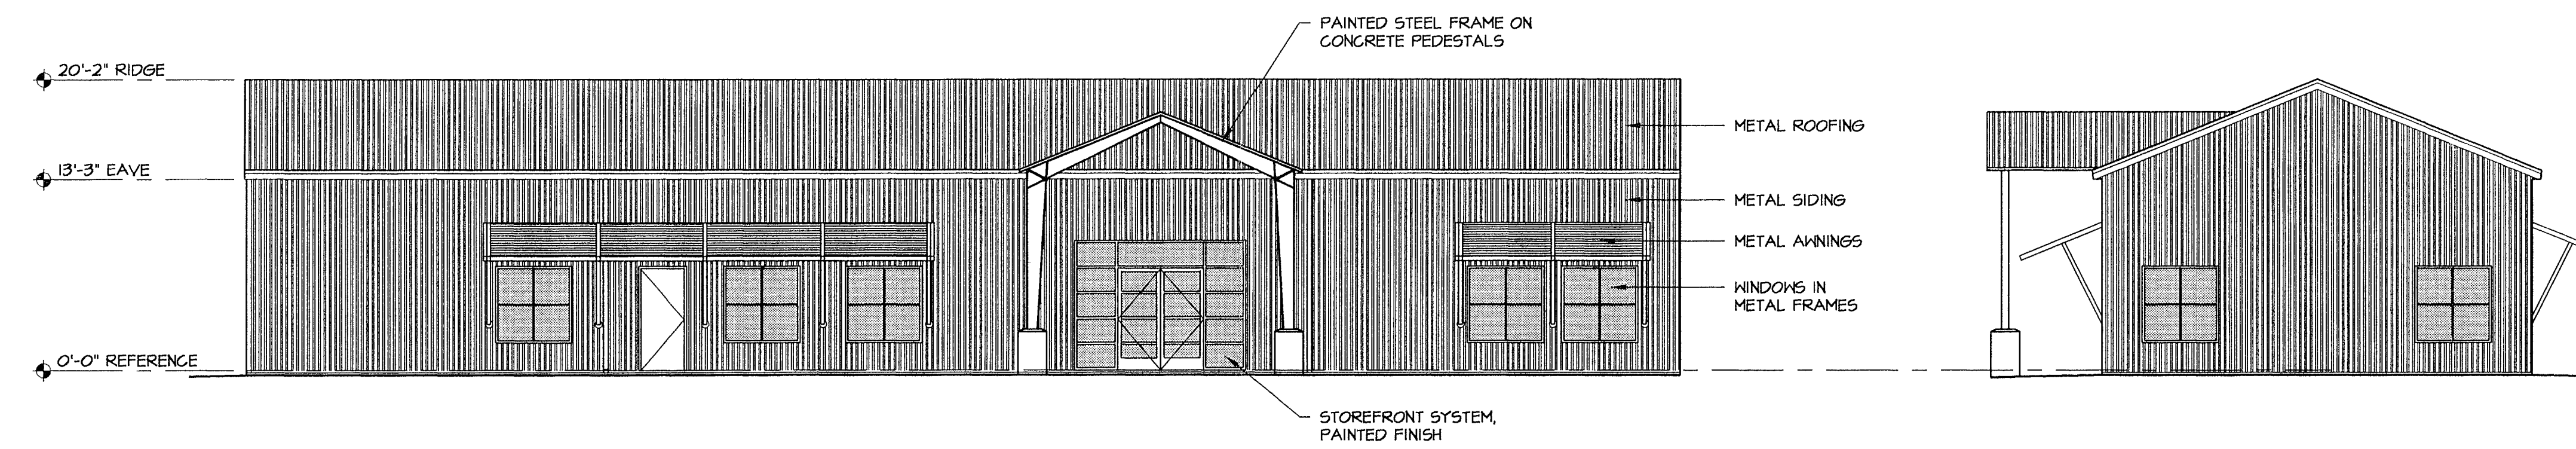

EAST ELEVATION

NORTH ELEVATION

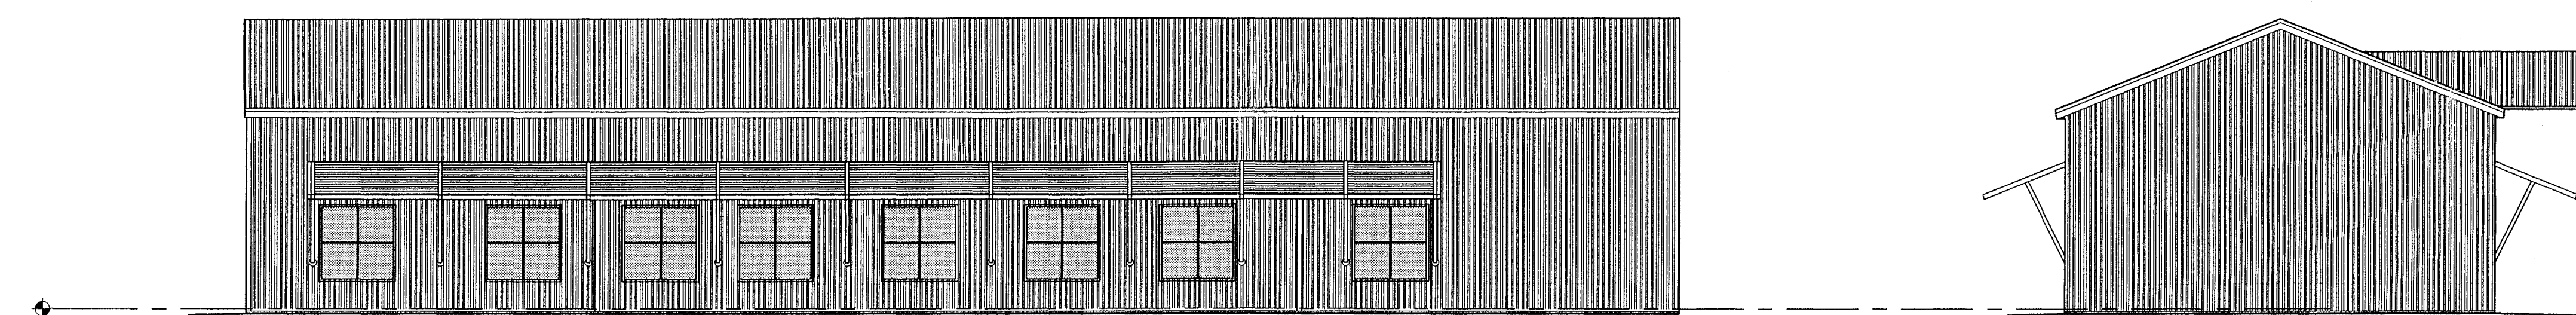


WEST ELEVATION

SOUTH ELEVATION



ADMINISTRATION BUILDING

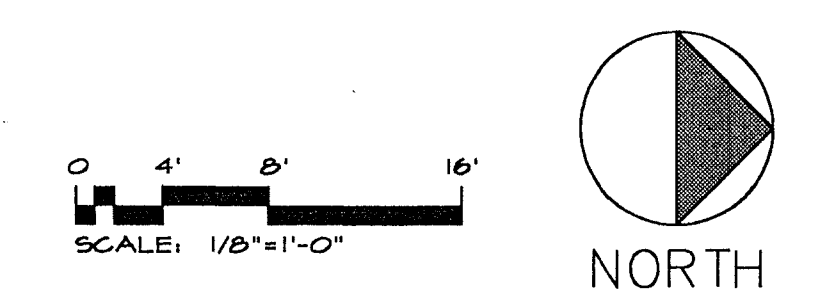


WEST COUNTY TRANSPORTATION

APRIL 19, 2000


- TORO XP300P-XX-05 POP-UP TURF ROTOR; 4.23 GPM FOR FULL HEAD @ 40 PSI; 0.56 INCHES PER HOUR
- TORO XP300P-XX-10 POP-UP TURF ROTOR; 8.58 GPM FOR FULL HEAD @ 40 PSI; 0.636 INCHES PER HOUR
- TORO 570Z-12PRX-CV-15MPR-PC SPRAY HEAD, 15'R @ 30 PSI, 0.75-3.00 GPM, 1.49 IN/HR
- TORO 570Z-12PRX-CV-12MPR-PC SPRAY HEAD, 12'R @ 30 PSI, 0.48-1.92 GPM, 1.49 IN/HR
- TORO 570Z-12PRX-CV-10MPR-PC SPRAY HEAD, 10'R @ 30 PSI, 0.33-1.33 GPM, 1.49 IN/HR
- TORO 570Z-12PRX-CV-8MPR-PC SPRAY HEAD, 8'R @ 30 PSI, 0.22-0.85 GPM, 1.54 IN/HR
- TORO 570Z-12PRX-CV-5MPR-PC SPRAY HEAD, 5'R @ 30 PSI, 0.09-0.35 GPM, 1.61 IN/HR
- TORO 570Z-12PRX-CV-4S-SST-PC SPRAY HEAD, 4x18'STRIP @ 30 PSI, 0.50 GPM, 1.34 IN/HR
- RAINBIRD ESP-24MC, 24 STATION IRRIGATION CONTROLLER
- GRISWOLD 2000 SERIES REMOTE CONTROL VALVE
- WILKINS 975 REDUCED PRESSURE (RP) BACKFLOW PREVENTER
- RAINBIRD 44NP QUICK COUPLING VALVE


- SCHEDULE 40 PVC MAIN LINE
- SCHEDULE 40 PVC LATERAL LINE
- SCHEDULE 40 PVC SLEEVE WITH SIZE
- CONTROLLER / STATION NUMBER
- GALLON PER MINUTE OF ZONE
- VALVE SIZE

NOTE:
MAIN LINE AND LATERAL LINES ARE SHOWN DIAGRAMMATICALLY. AVOID TRENCHING UNDER DRIP LINES OF EXISTING TREES.

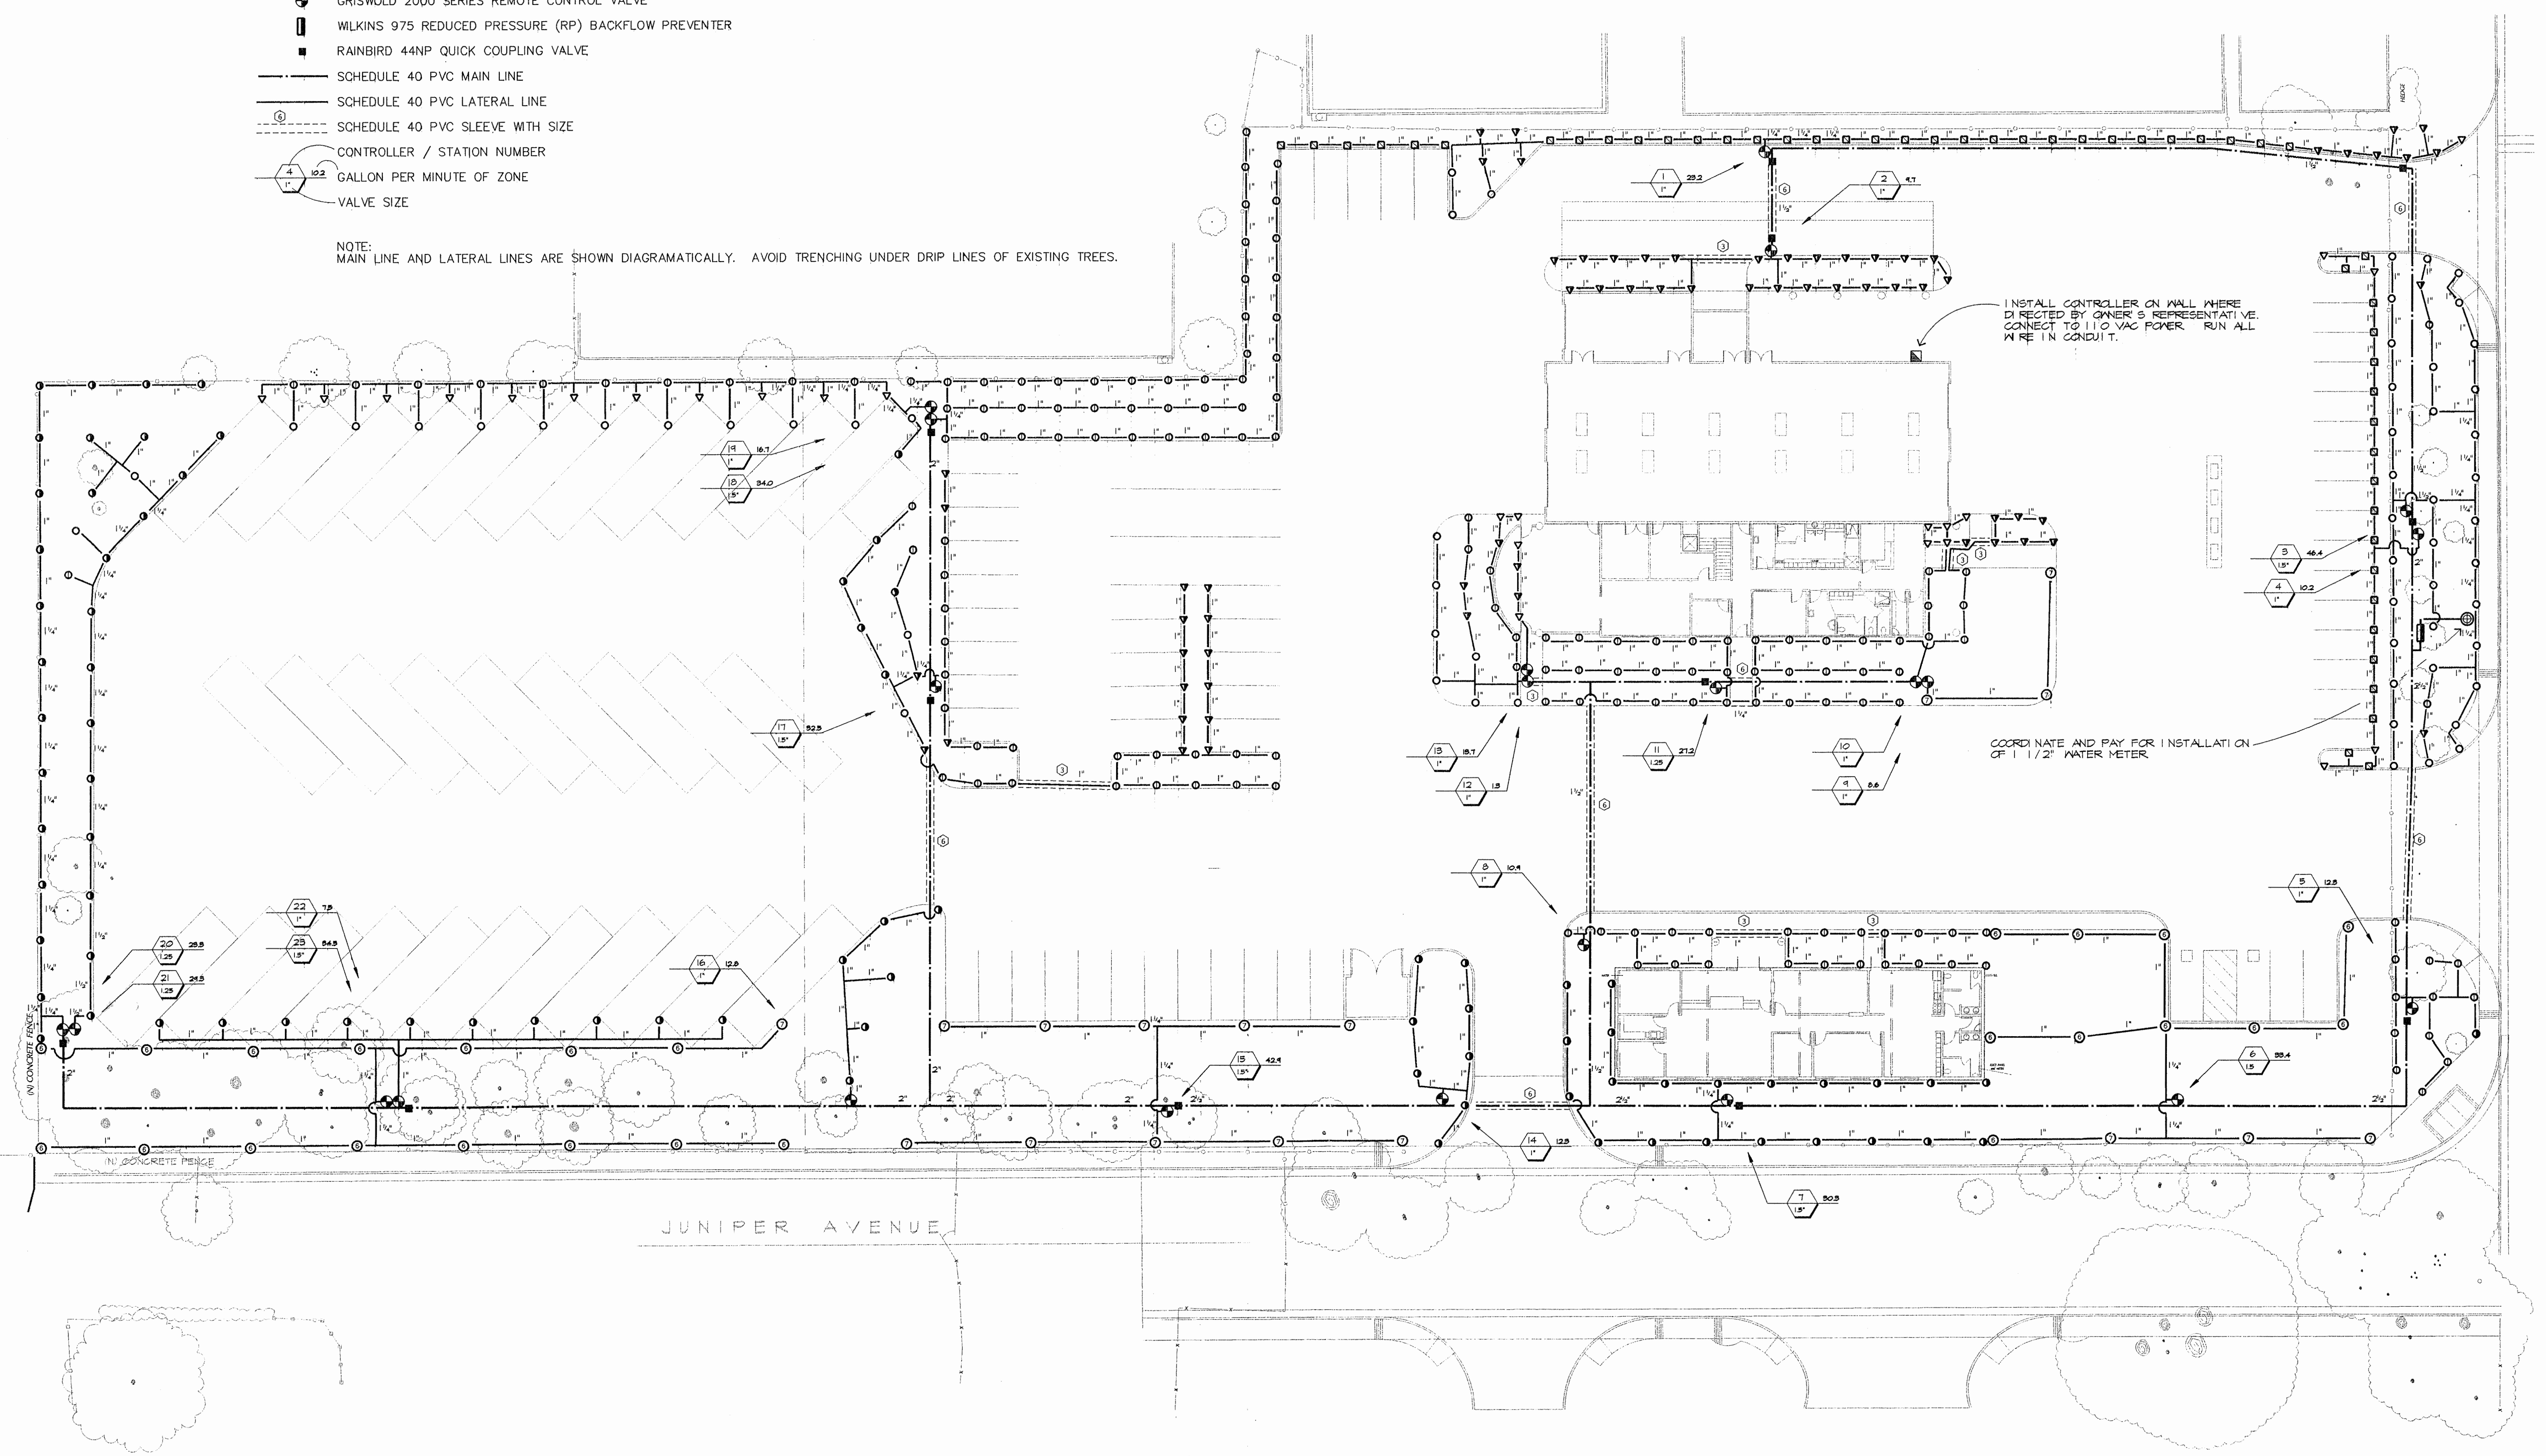


IRRIGATION PLAN
1" = 20'

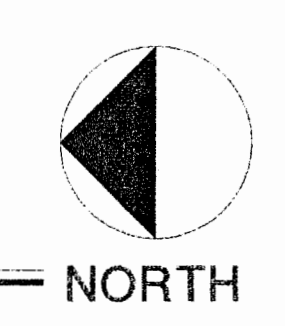

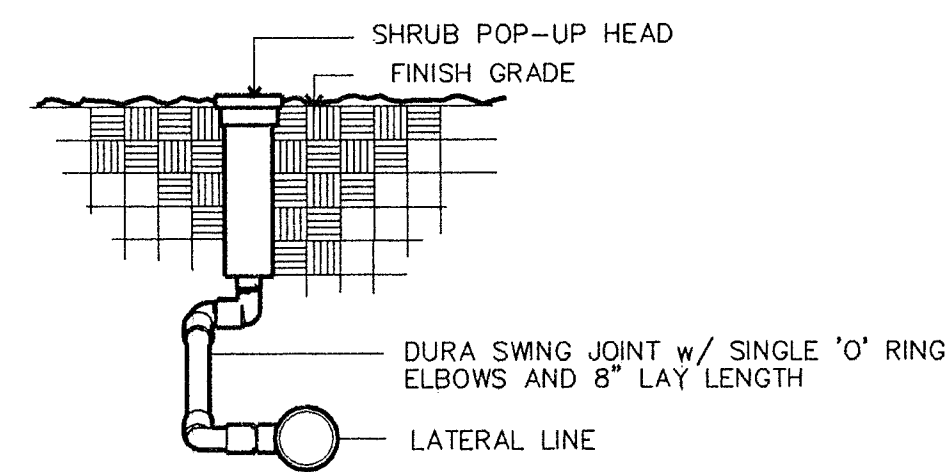


SHRUB POP-UP SPRAY HEAD

NTS

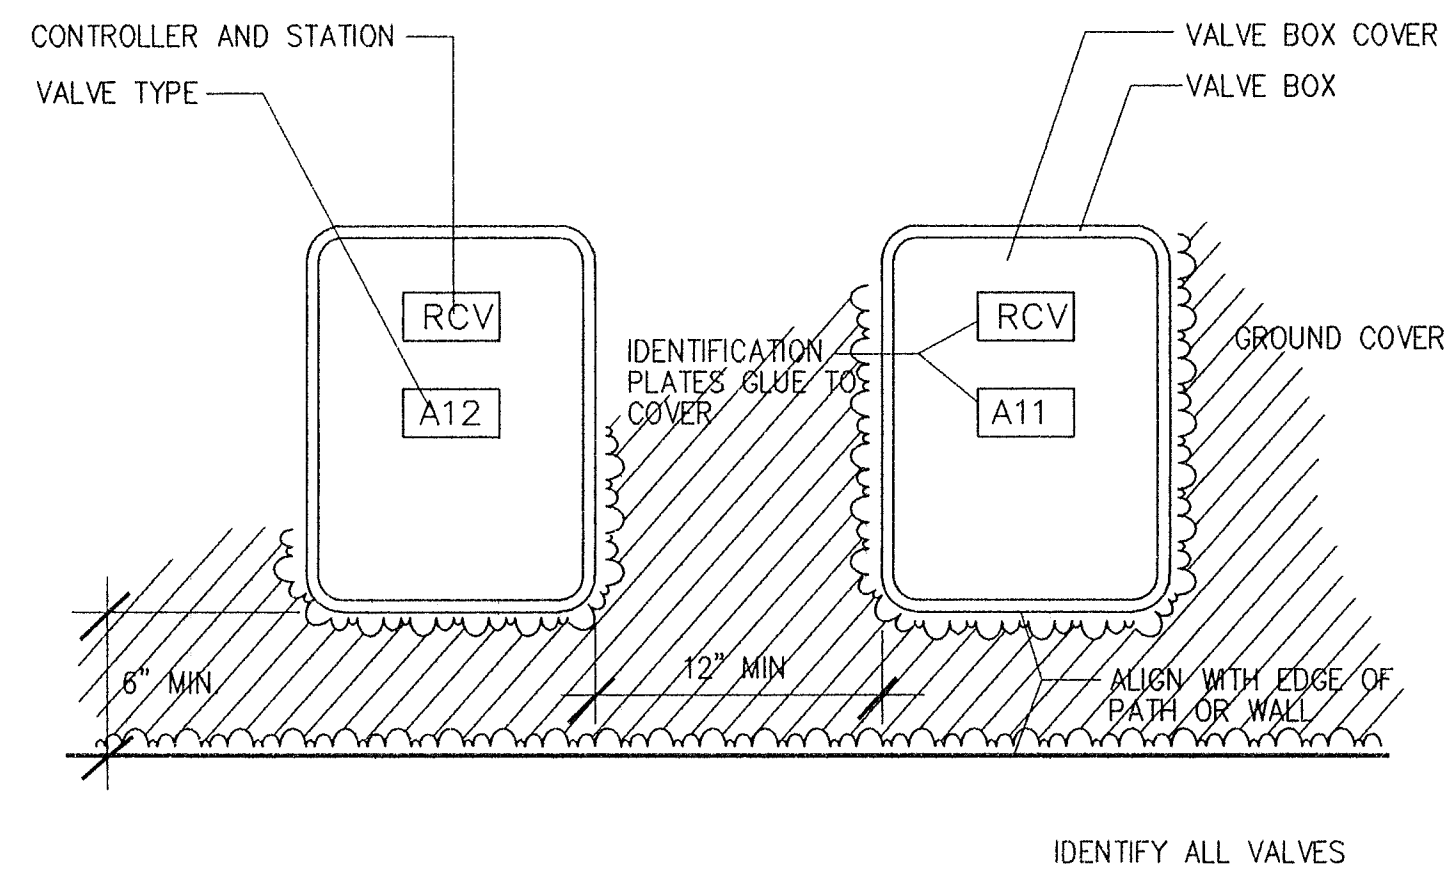


VALVE BOXES

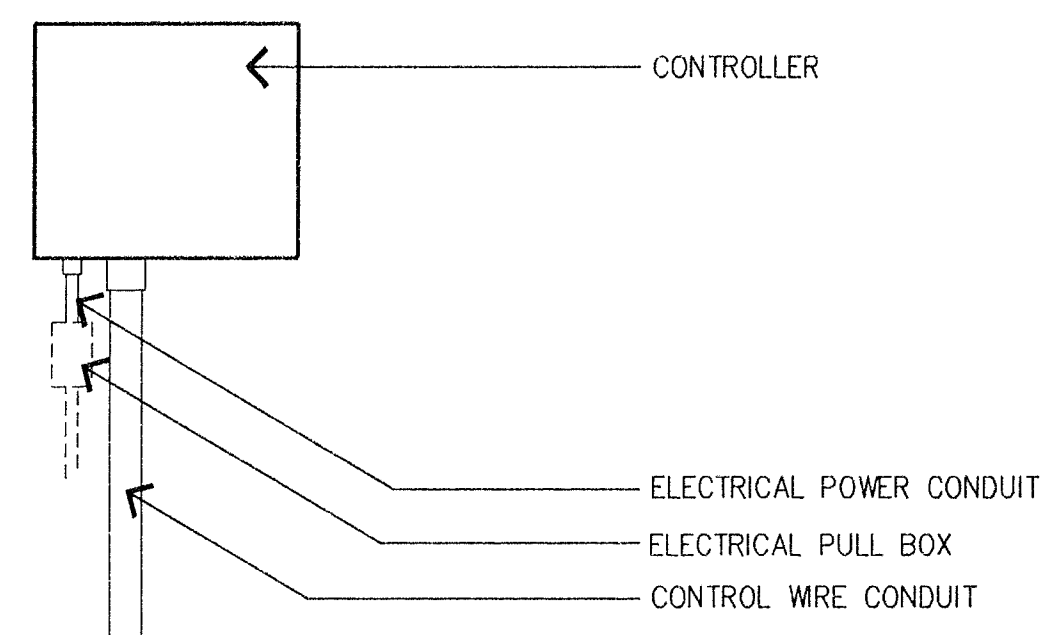


WALL MOUNT CONTROLLER

ELEVATION

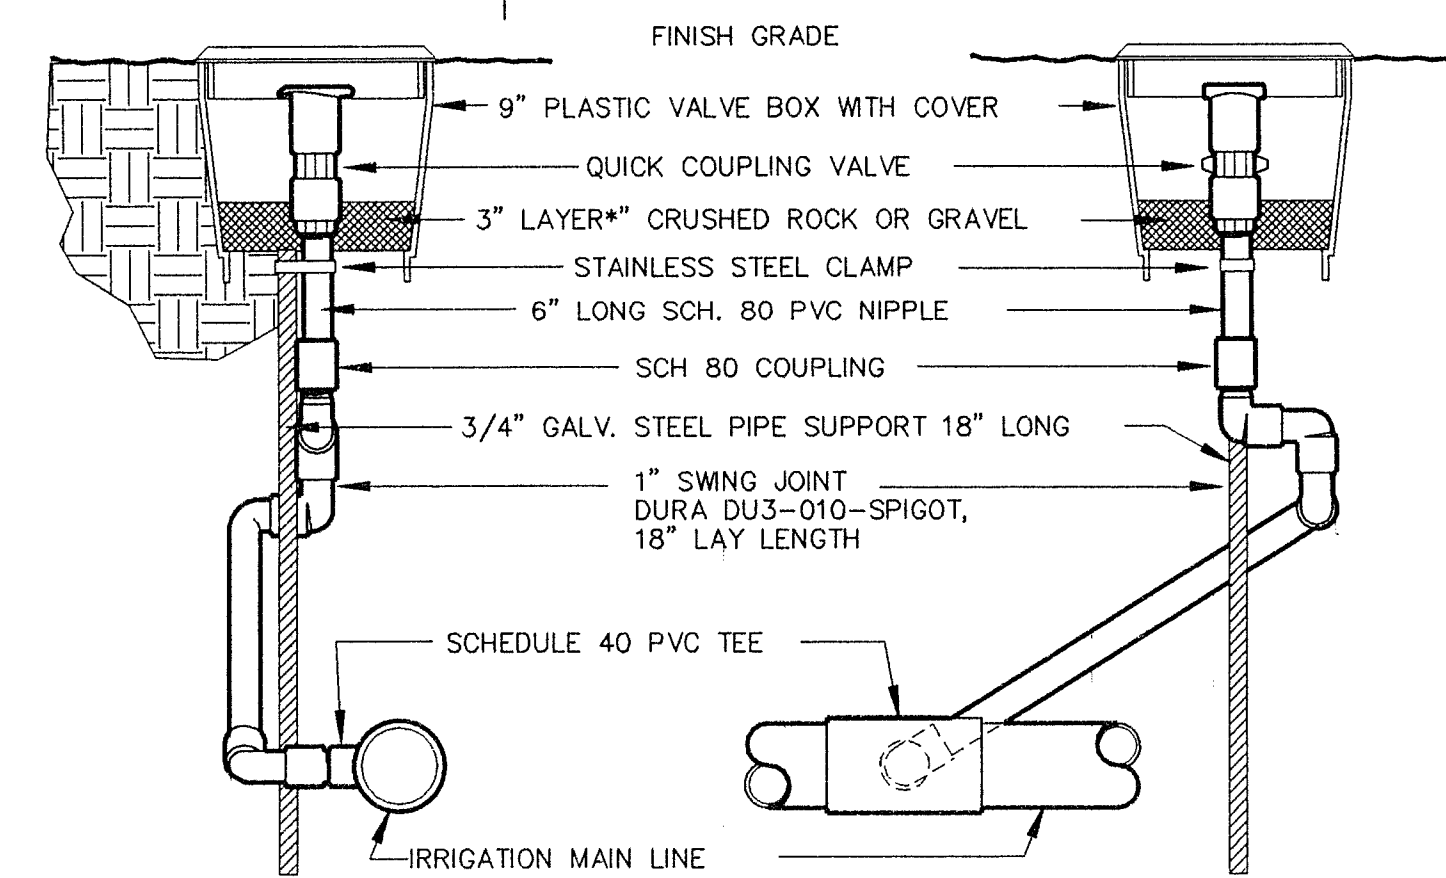


QUICK COUPLING VALVE

NTS

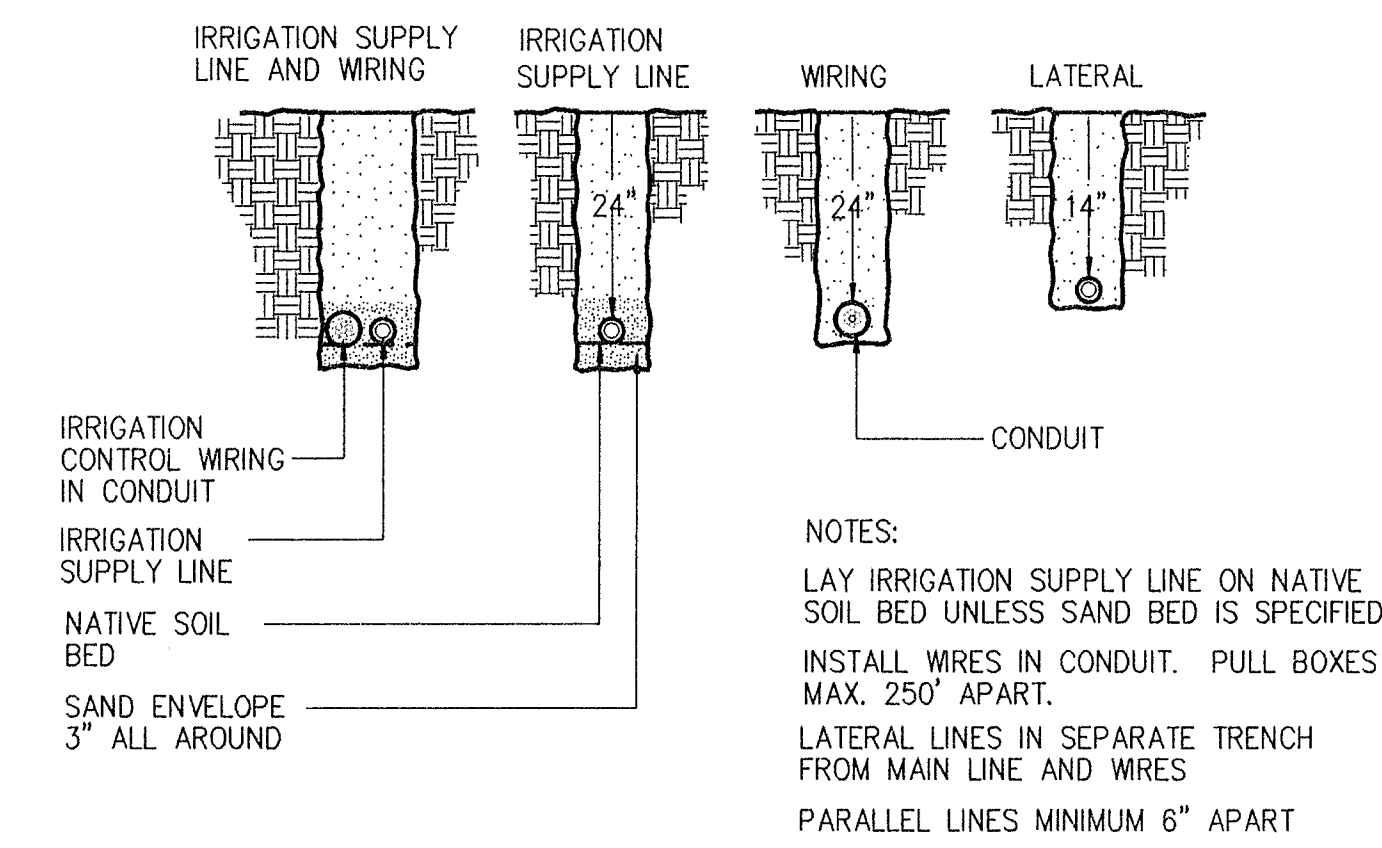


TRENCHING AND INSTALLATION

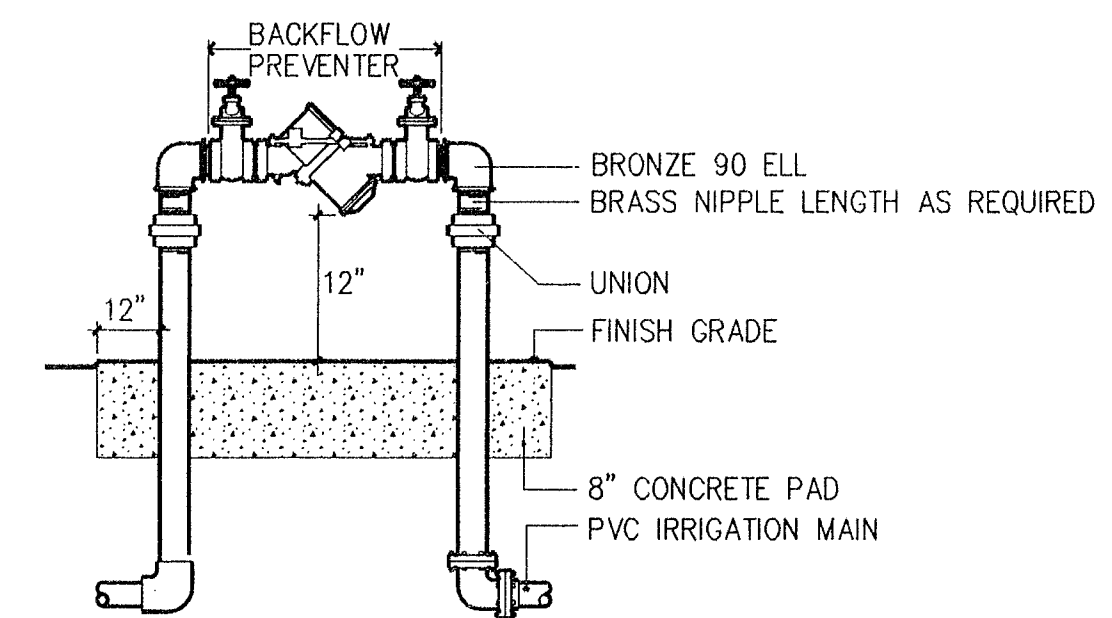


REDUCED PRESSURE BACKFLOW PREVENTER

NTS

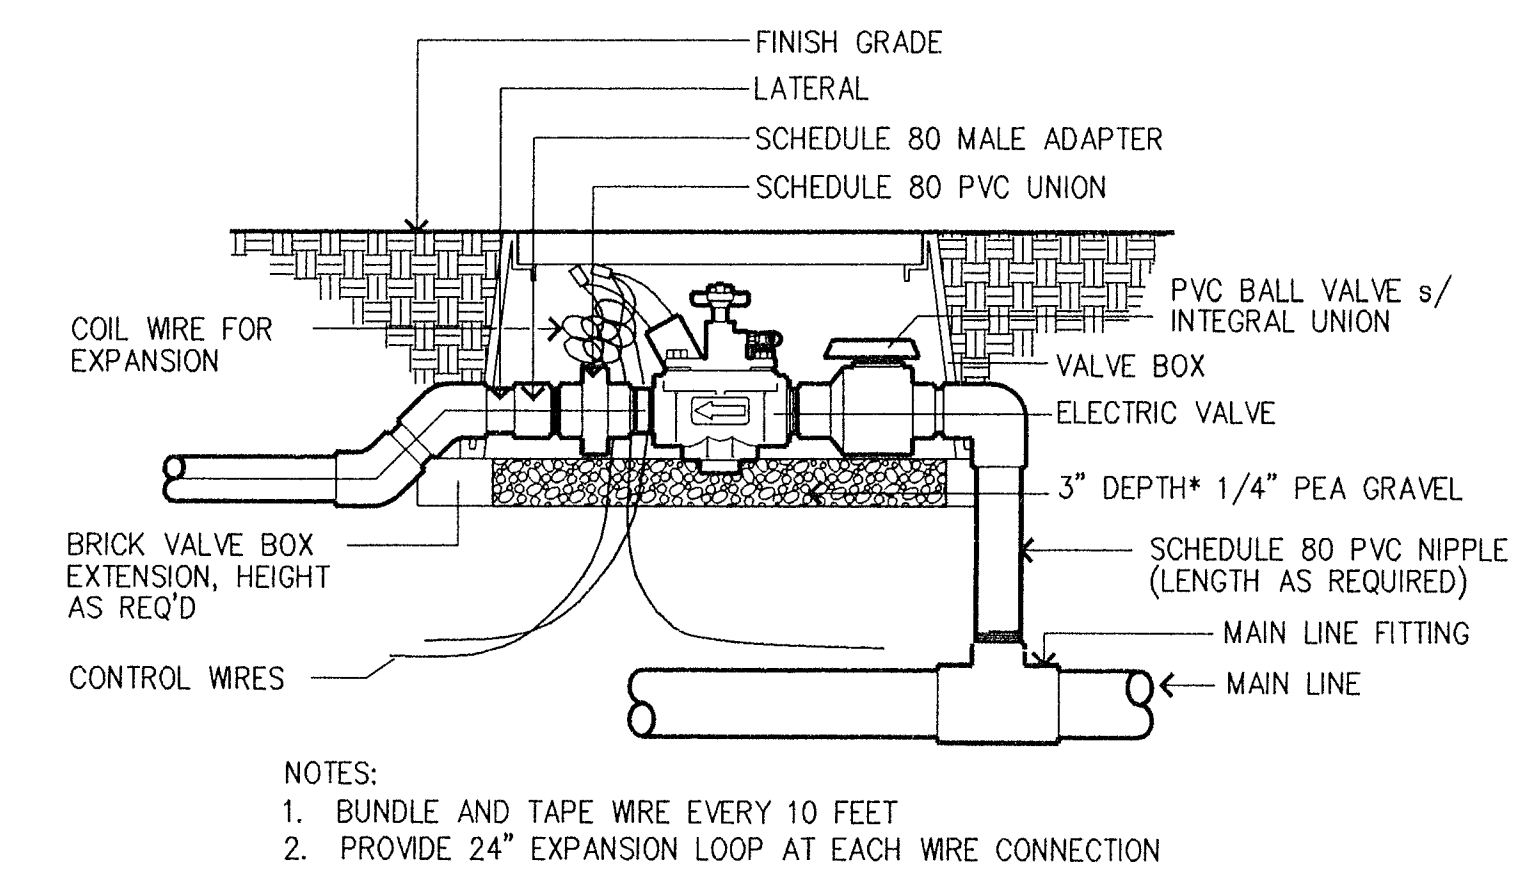

REMOTE CONTROL VALVE

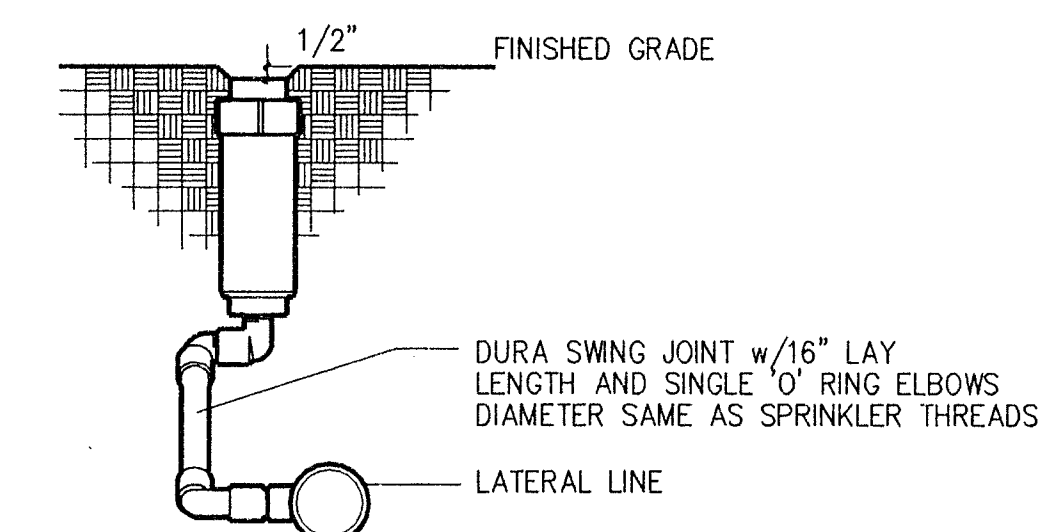


ROTOR

GLASS
ARCHITECTS

200 E STREET
Suite 100
Santa Rosa, CA 95404
Tel: (707) 544-3920
Fax: (707) 544-2514

© Copyright 1999

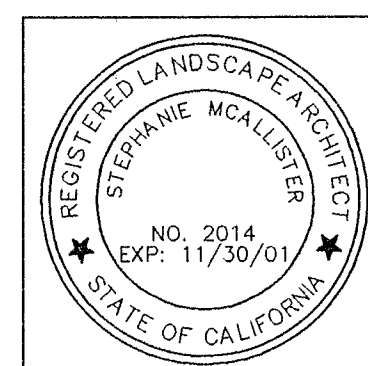

Stephanie McAllister Landscape Architecture
145 Keller Street
Petaluma, CA 94952
Telephone: (707) 778-7693
Facsimile: (707) 778-7647

West County
Transportation
WCTA BUS MAINTENANCE FACILITY

IRRIGATION DETAILS

Job No: G9717
Drawn By: DLW
Checked By: DLW
Cod File:
Date: 19 JULY '00

Revisions


Sheet Number

L1.2

of 4


PLANT LIST

SYMBOL	BOTANICAL NAME	COMMON NAME	SIZE	SPECIFICATIONS/COMMENTS
TREES:				
AR	ACER RUBRUM 'RED SUNSET'	RED MAPLE	15 GALLON	7-8' HT. X 2-3' WD.
AC	ALNUS CORDATA	ITALIAN ALDER	15 GALLON	7-8' HT. X 2-3' WD.
LI	LAGERSTROEMIA FAUREI 'COMANCHE'	ORANGE MYRTLE	15 GALLON	7-8' HT. X 2-3' WD.
LI	LAGERSTROEMIA INDICA 'RUBRA'	ORANGE MYRTLE	15 GALLON	7-8' HT. X 2-3' WD.
PC	PISTACIA CHINENSIS	CHINESE PISTACHE	15 GALLON	7-8' HT. X 2-3' WD.
RO	ROBINIA AMBIGUA 'PURPLE ROBE'	BLACK LOCUST	15 GALLON	7-8' HT. X 2-3' WD.
SS	SEQUOIA SEMPERVIRENS 'SANTA CRUZ'	REDWOOD	15 GALLON	6-7' HT. X 2-3' WD.
SHRUBS, VINES AND GRASSES:				
BD	BUDDLEIA DAVIDII 'BLACK KNIGHT'	BUTTERFLY BUSH	5 GALLON	
CL	COTONEASTER LACTEUS	PARNEY COTONEASTER	5 GALLON	4'-0" O.C.
CO	COTONEASTER 'LOUFAT'	SPREADING COTONEASTER	1 GALLON	3'-0" O.C.
FF	FICUS FUMILA	CREeping FIG	1 GALLON	STAKED
JP	JASMINUM POLYANTHUM	JASMINE	5 GALLON	
LS	LEPTOSPERMUM SCOPARIUM 'H. STREYBLING'	NEW ZEALAND TEA TREE	5 GALLON	
LH	LONGICERA HECKROTTII	GOLD FLAME HONEYBUCKLE	5 GALLON	
MT	MISCANTHUS TRANSVORISONENSIS	EVERGREEN EULALIA GRASS	1 GALLON	
OD	OSMANTHUS DELAVAYI	DELAVAY OSMANTHUS	5 GALLON	
PT	PARTHENOCISSUS TRICUSPIDATA	BOSTON IVY	1 GALLON	STAKED
PI	PITTOSPORUM TENIPOLUM	PITTOSPORUM	5 GALLON	3'-0" O.C.
RA	PITTOSPORUM TOBIIRA 'VARIEGATA'	VARIEGATED PITTOSPORUM	5 GALLON	4'-0" O.C.
RE	RHAMNUS ALATERNUS	ITALIAN BUCKTHORN	5 GALLON	4'-0" O.C.
TF	ROSA BANKSIAE 'LUTEA'	YELLOW BANKS' ROSE	5 GALLON	
TF	TEUCRIUM FRUTICANS	BUSH GERMANDER	5 GALLON	
GROUNDCOVERS AND PERENNIALS:				
	CAMPANULA POSCHARYANA	BELLFLOWER	4" POTS	18" O.C.
	LAVANDULA 'PROVENCE'	PROVENCE LAVANDER	4" POTS	18" O.C.
	NEPETA FAASSENII	CATMINT	4" POTS	18" O.C.
	PACHYSANDRA TERMINALIS	JAPANESE SPURGE	PLANTS	12" O.C.
	PENSTEMON 'MIDNIGHT'	PENSTEMON	4" POTS	18" O.C.
	VINCA MINOR	DWARF PERIWINKLE	PLANTS	12" O.C.

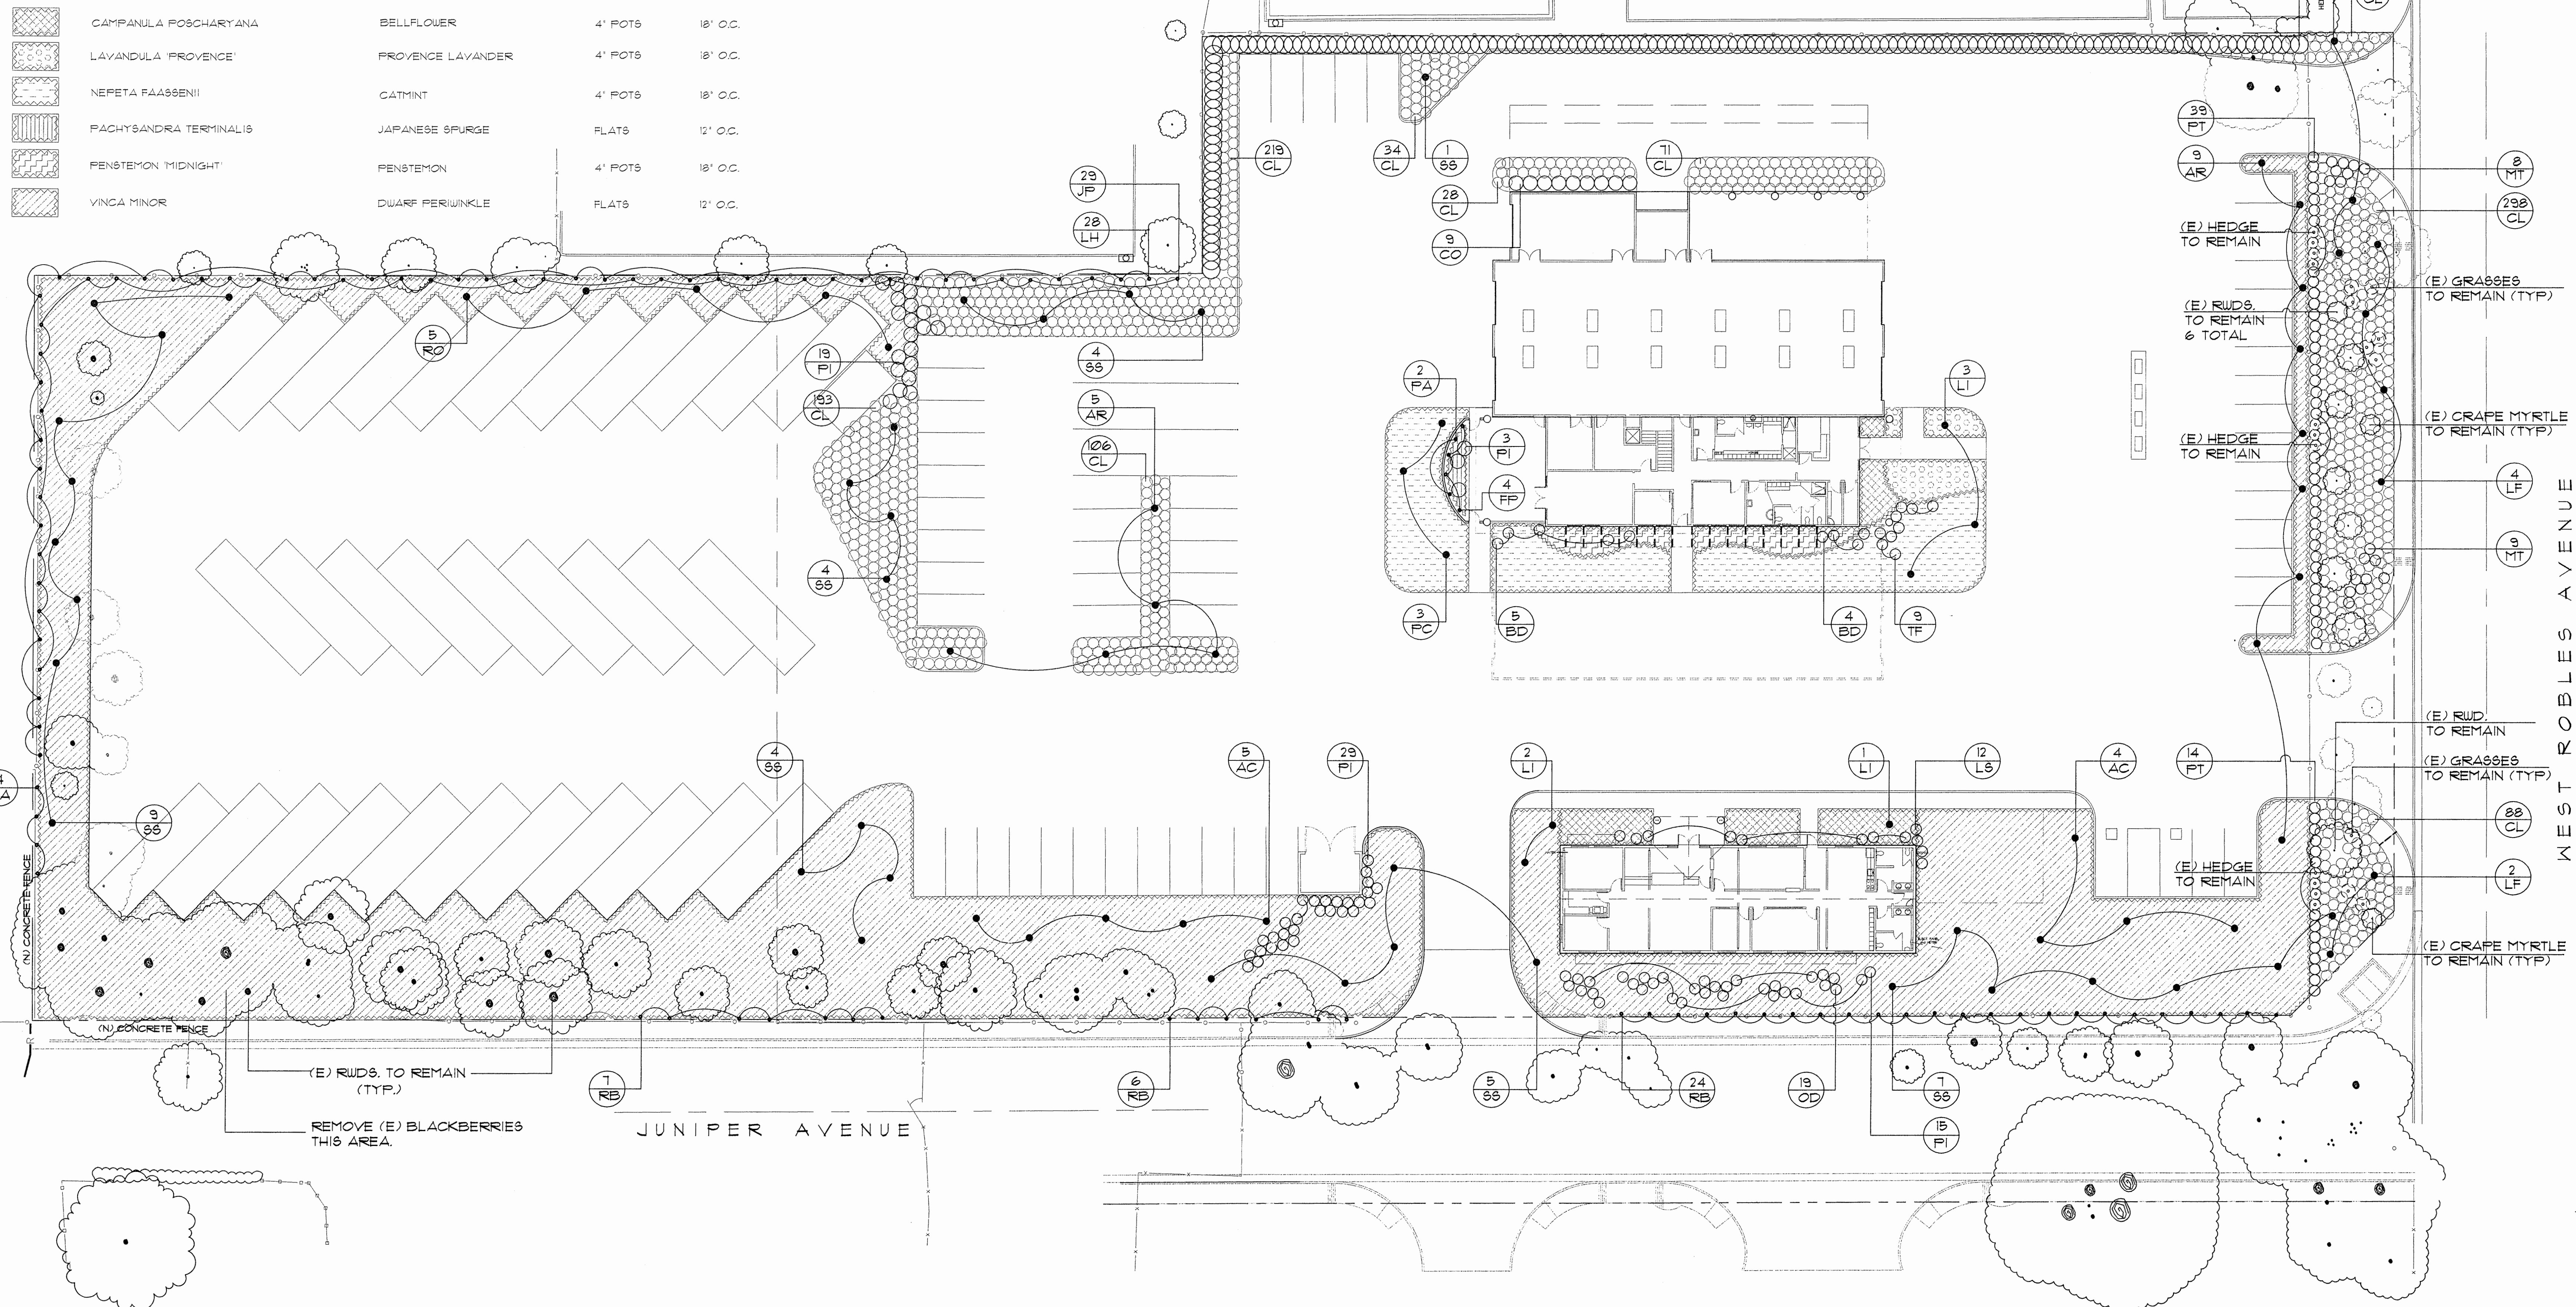

PLANTING PLAN


1" = 20'

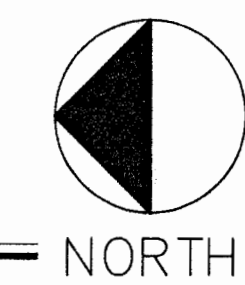

GLASS
ARCHITECTS

200 E. STREET
Suite 100
Santa Rosa, CA 95404
Tel: (707) 544-3920
Fax: (707) 544-2514

© Copyright 1999

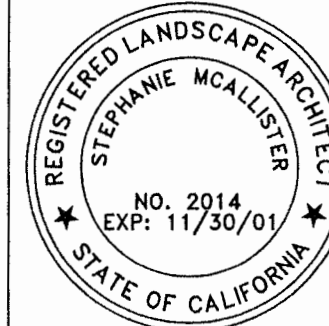

Stephanie McAllister Landscape Architecture
145 Keller Street
Petrolia, CA 95559
Telephone: (707) 778-7893
Facsimile: (707) 778-7847

West County
Transportation
WCTA BUS MAINTENANCE FACILITY

PLANTING PLAN


Job No: 09717
Drawn By: SM
Checked By: SM
Cdd File: L2.1
Date: 19 JULY '00

Revisions


Sheet Number

L2.1


of 4

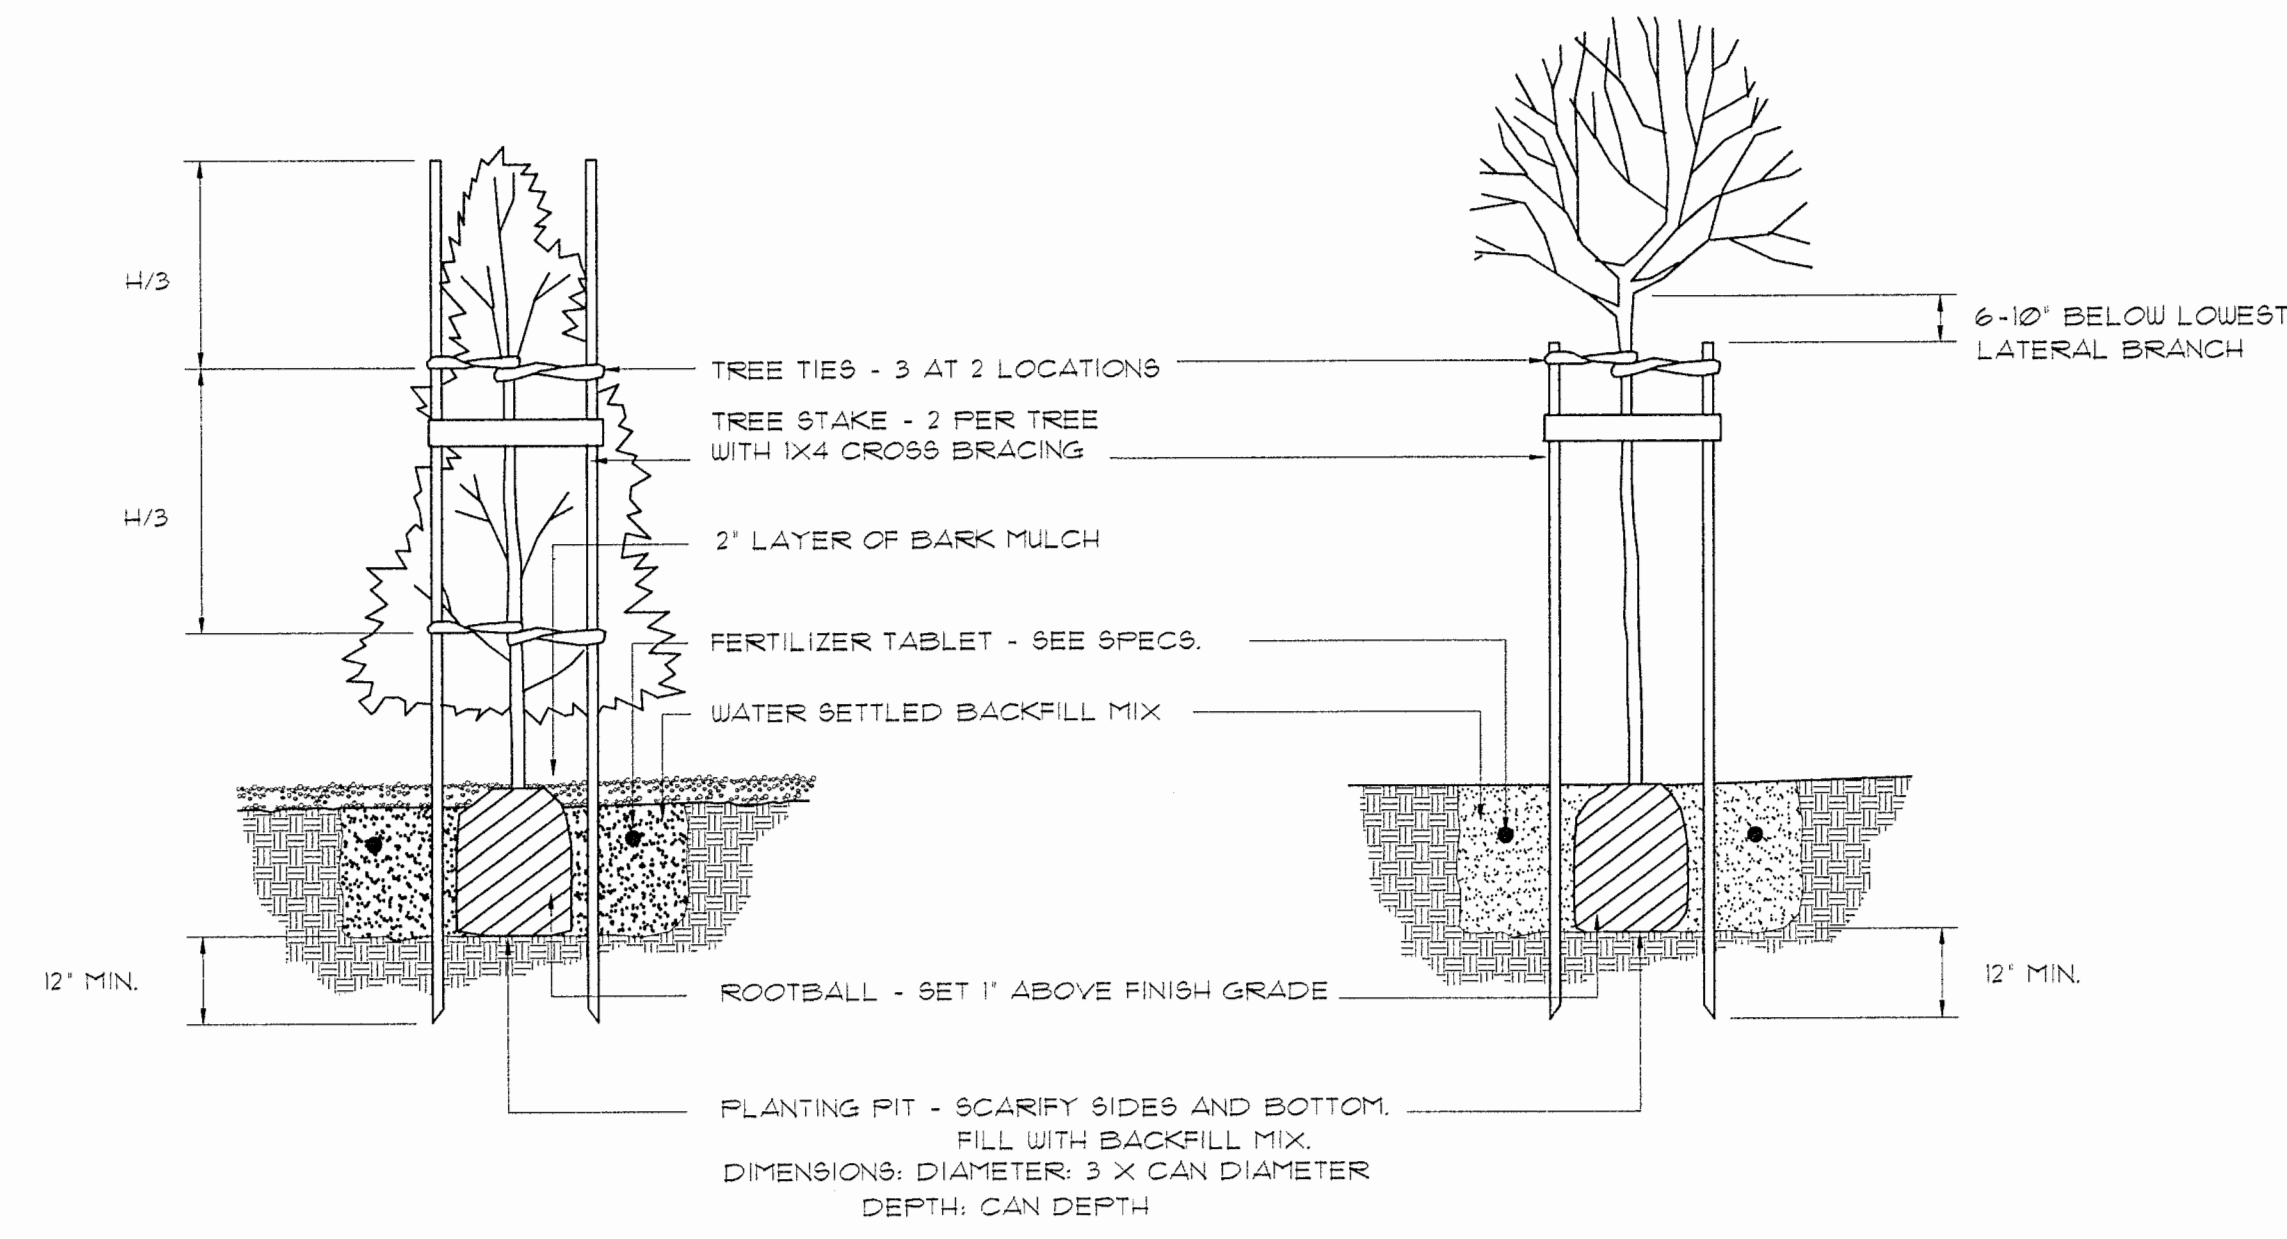


4 TREE PLANTING DETAIL
NOT TO SCALE

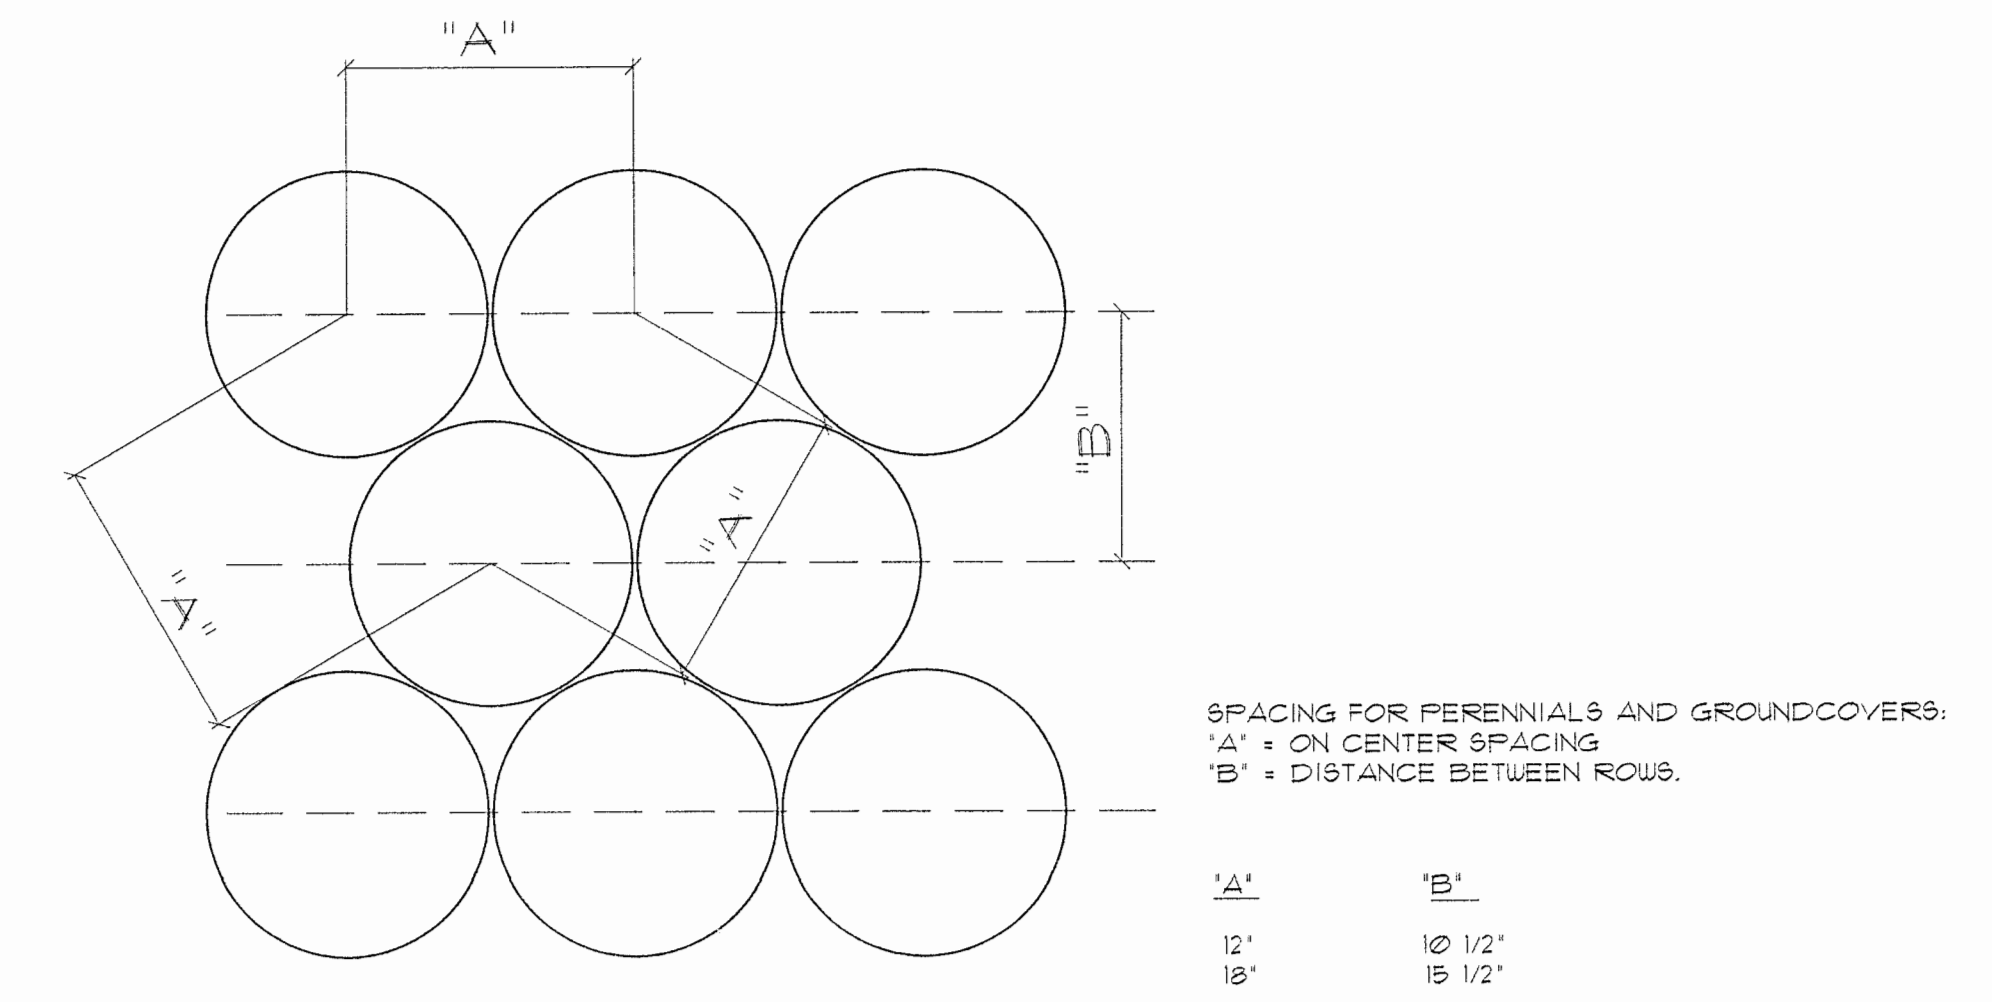

1 TRIANGULAR SPACING DIAGRAM
NOT TO SCALE

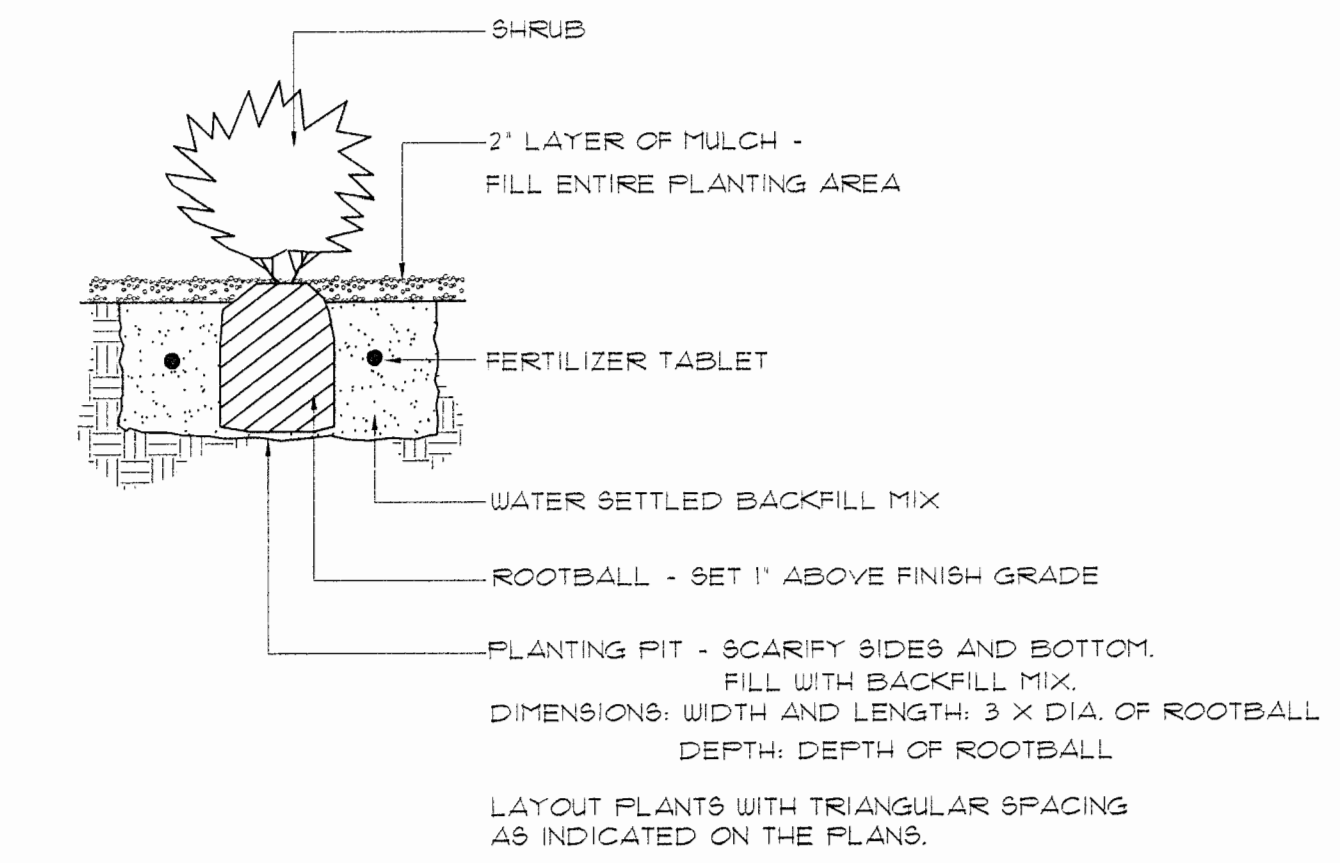

2 SHRUB PLANTING DETAIL
NOT TO SCALE

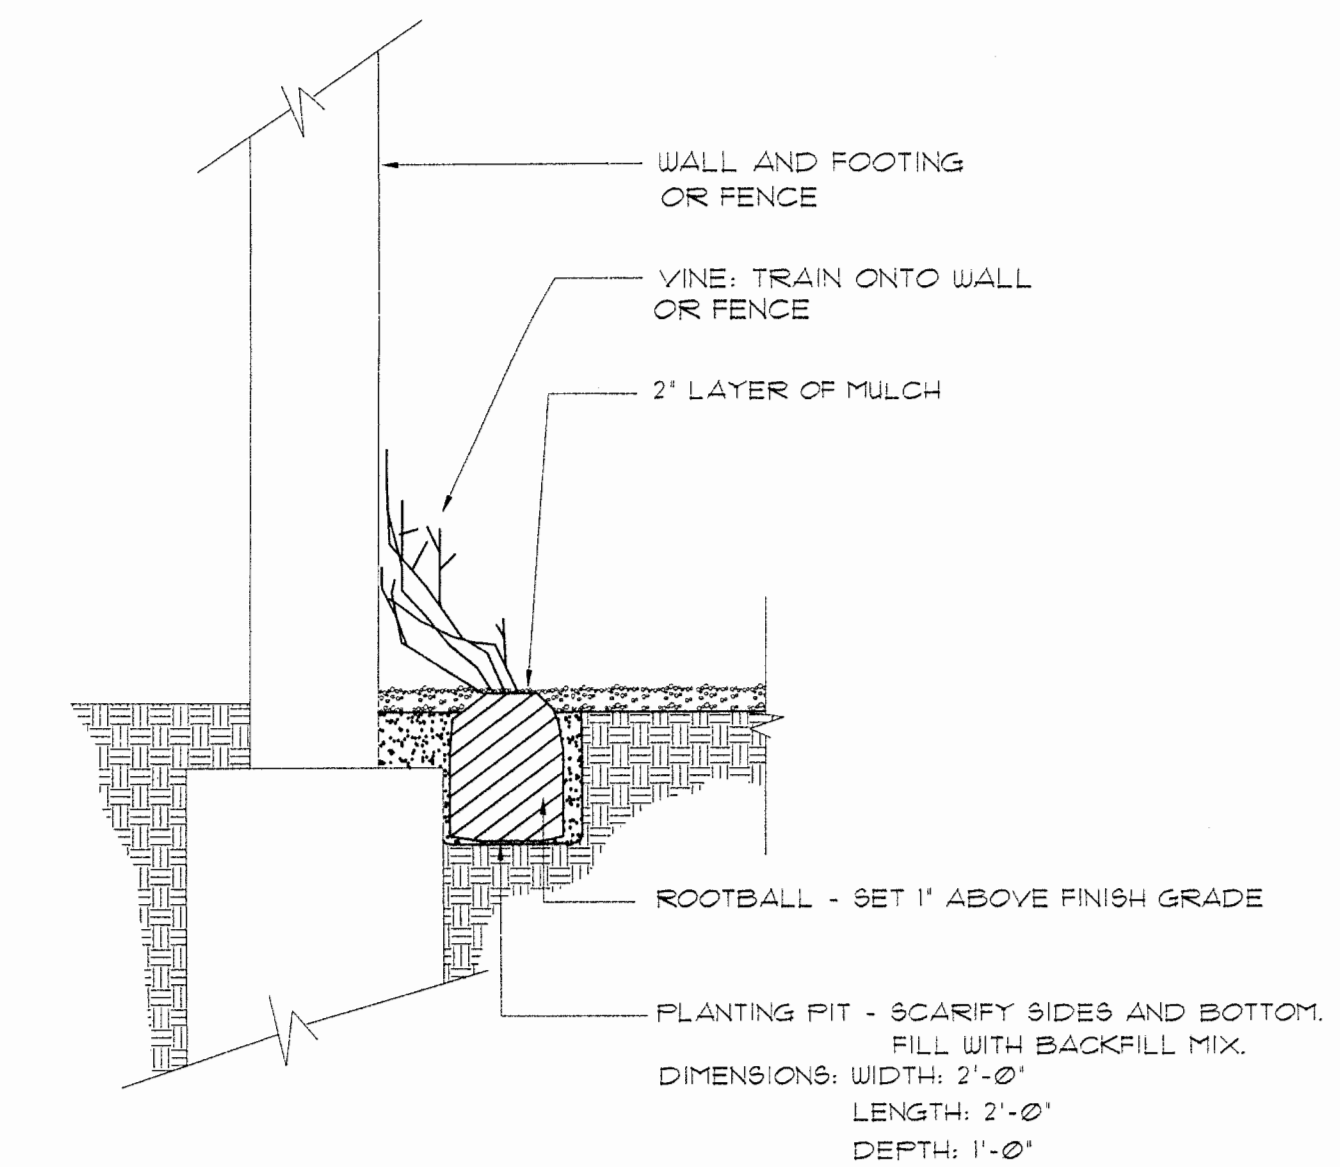

3 VINE PLANTING DETAIL
NOT TO SCALE